



PRO™

Prototypical Details



These drawings are for communication of design intent only. These drawings are not suited or intended for construction or fabrication.

OVERVIEW - EXTERIOR

| 100

THESE ARE SUGGESTED VENDORS AND YOU ARE WELCOME TO SUBMIT EQUIVALENT SPECS FOR OUR REVIEW

	APPLICATION	MANUFACTURER / SUPPLIER	REPRESENTATIVE'S NAME	CONTACT INFORMATION	USE OF SUPPLIER
Exterior Finishes	Metal Panel	Arconic	Alisa Bollinger	P: 478-230-3600 E: alisa.bollinger@arconic.com	Mandatory
	Metal Panel Alt	PAC-CLAD	Tony Sauve	P: 989-205-3531 E: tsauve@petersenmail.com	Alternative
	Paint (Exterior/Interior)	Sherwin Williams	Dawn Cenowa	P: 248-660-3067 E: dawn.m.cenowa@sherwin.com	Mandatory
	Glazing System	Kawneer	Doug Hess	P: 570-389-6235 E: doug.hess@arconic.com	Mandatory
	Glass	PPG	Joseph Sennese	P: 630-962-4800 E: jsennese@vitro.com	Mandatory
Interior Finishes	Tile	Virginia Tile	Stephan Reinig	P: 800 - 514 - 8453	Mandatory
	Carpet	Shaw Contract	Nichole Pikur	E: www.shawcontract.com E: nichole.pikur@shawcontract.com	Mandatory
	Laminate	Wilsonart	Leslie Humpfries	P: 800-433-3222 E: www.wilsonart.com	Mandatory
	Epoxy Coating	Sherwin Williams	Dawn Cenowa	P: 248-660-3067 E: dawn.m.cenowa@sherwin.com	Mandatory
	Solid Surface	Corian	Sabrina Kassab	P: 586-980-2413 E: skassab@oldenkamp.com	Mandatory
Interior Elements	Furniture	MarxModa	Melinda Kimmer	C: 217.821.1490 E: fordretail@marxmoda.com	Mandatory
	Furniture	MFG		E: orders@mfgint.com	Mandatory
	Ceiling Baffles	Acoufelt	Ronald Truan	E: ronald.truan@acoufelt.com	Mandatory
Signage	.	Ford Retail Identification	Kelly Retterer	P: 888-856-7880 ext 2 F: 865-622-6505 E: kkretterer@agi.net Locations: Philadelphia, Dallas, Detroit, Houston, Washington, Atlanta, Charlotte, Memphis, Boston, Chicago, Pittsburgh	Mandatory
	.	Ford Retail Identification	Sherry Dopwell	P: 888-856-7880 ext 3 F: 865-622-6505 E: sdopwell@agi.net Locations: New York, Denver, Seattle, Twin Cities, Phoenix, Orlando, Kansas City, Los Angeles, San Francisco, Cincinnati	Mandatory
	.	.			Mandatory
Equipment	Rotunda	Mountain / West / Alaska	Aaron Gwin	P: 510-421-5190 E: Agwin1@Ford.com	
		Southwest	Paul Hastings	P: 936-727-1841 E: Phastin6@Ford.com	
		Northeast	William Moore	P: 908-210-1632 E: Wmoor137@Ford.com	
		North Central	Cory Harris	P: 224-257-1570 E: Charr368@Ford.com	
		Southeast	Mike Hickam	P: 978-302-3122 E: Mhickam@Ford.com	
		Central	Ken Smith	P: 504-258-4728 E: Ksmit544@Ford.com	
		Great Lakes	Wayne Sutherland	P: 313-418-0227 E: Wsuther8@Ford.com	
Lighting		CED Automotive	Dan Rodriguez	P: 562-964-5995 E: dan.rodriguez@cedslc.com	
Key Management		KeyMaster	-	P: 952-448-7000 E: Sales@1Micro.com	
		Key Cafe	Mitchell Luis	E: mitchell@keycafe.com E: sales@keycafe.com	



PRO™

Prototypical Details

These drawings are for communication of design intent only. These drawings are not suited or intended for construction or fabrication.



VENDOR CONTACT INFORMATION

| 300



PRO™

Prototypical Details

							
FIXTURE TYPE	F1	F1A	F2	F3	F4	F5	F6
LOCATION	OFFICES, RESTROOMS, STAIRWELLS	GUEST WAITING & TRAINING LOUNGE	RECEPTION	CUSTOMER RECEPTION TABLE	GENERAL OFFICES, IT ROOM, JANITOR, FILE STORAGE	PARTS, OIL & COMPRESSOR ROOM, PARTS DELIVERY	PARTS, OIL & COMPRESSOR ROOM, PARTS DELIVERY
FIXTURE PART #	RTN-HC615D010-HM612840-61WDH	RTN-PRS6FS12-SM6128FS-64SWDH	RTN-SQ4-F-0U-075D-840-1D-UNV-STD-W-12	FORD PRO SIGNATURE PENDANT	RTN-22CZ2-32-S-UNV-L840-CD1-U	RTN-8TSNLED-LD5-81SL-LW-UNV-L840-CD1	RTN-4SNLED-LD5-44SL-LW-UNV-L840-CD1
DESCRIPTION	6" ROUND RECESSED DOWNLIGHT	6" SQUARE RECESSED DOWNLIGHT	144" DIRECT ILLUMINATION LINEAR	72" - DIRECT ILLUMINATION LINEAR	2X2 ARCHITECTURAL TROFFER	8' LINEAR STRIP W/ ROUND LENS	4' LINEAR STRIP W/ ROUND LENS
LIGHT SOURCE	LED	LED	LED	LED	LED	LED	LED
CRI PERFORMANCE	80 CRI	80 CRI	80 CRI	80 CRI	80 CRI	80 CRI	80 CRI
COLOR TEMPERATURE (K)	4000K	4000K	4000K	4000K	4000K	4000K	4000K
SUGGESTED WATTAGE	14W	14W	52W	60W	24W	69W	38W
DIMMING CAPABLE	YES	YES	YES	YES	YES	YES	YES
EMERGENCY CAPABLE	YES	YES	YES	YES	YES	YES	YES
FIXTURE FINISH	SATIN HAZE REFLECTOR w/ MATCHING TRIM	SATIN HAZE REFLECTOR w/ MATCHING TRIM	WHITE w/ SOFT FOCUS FLUSH ACRYLIC LENS	FORD PRO BLUE WITH SOFT FOCUS REGRESSED ACRYLIC LENS	WHITE WITH FROSTED LENS	WHITE WITH FROSTED LENS	WHITE WITH FROSTED LENS
MOUNTING	RECESSED	RECESSED	CABLE SUSPENSION	CABLE SUSPENSION	RECESSED	SUSPENDED OR SURFACE MOUNT	SUSPENDED OR SURFACE MOUNT
NOTES			FIXTURES SHALL BE SUSPENDED FLUSH WITH BOTTOM OF CEILING STRUCTURE WITH PROVIDED ADJUSTABLE CABLING	FIXTURES SHALL BE SUSPENDED OVER CUSTOMER RECEPTION TABLE WITH PROVIDED ADJUSTABLE CABLING	SPECIFY DRYWALL KIT FOR GYP CEILINGS	BUILT-IN ROW ALIGNER INCLUDED WHERE FIXTURES ARE TO BE INSTALLED IN CONTINUOUS ROWS	BUILT-IN ROW ALIGNER INCLUDED WHERE FIXTURES ARE TO BE INSTALLED IN CONTINUOUS ROWS

ARCHITECT / ENGINEER NOTES:

- ALL LIGHTING SCHEDULES MUST INCLUDE THE FOLLOWING CONTACT INFORMATION
 PRICING & SPECIFICATION ASSISTANCE
 DAN RODRIGUEZ - CED AUTOMOTIVE
 dan.rodriquez@cedslc.com / 562.964.5995
- ALL FIXTURE PART #'s MUST INCLUDE THE PREFIX **RTN** TO GUARANTEE NATIONAL ACCOUNT PRICING
 EXAMPLE:
 TYPE F1 - **RTN**-HC615D010-HM612840-61WDH

These drawings are for communication of design intent only. These drawings are not suited or intended for construction or fabrication.







LIGHTING SCHEDULE

A 501



PRO™

Prototypical Details

 							
							
FIXTURE TYPE	F7	F8	F9	F9A	F10	F11	F12
LOCATION	SERVICE AREA	SERVICE AREA TASK LIGHTING	WET LOCATION AREAS	WET LOCATION AREAS	BUILDING EXTERIOR, GARAGE DOORS	PERIMETER POLE	INTERIOR POLE
FIXTURE PART #	RTN-VHB-24-N-UNV-L850-CD-U	RTN-8TSNLED-LD5-110HL-LW-UNV-L850-CD1	RTN-8VT2-LD5-12-DR-UNV-L850-CD2-WL	RTN-4VT2-LD5-8-DR-UNV-L850-CD1-WL	RTN-GWC-SA2B-750-U-T3-DP	RTN-PREVAIL*	RTN-PREVAIL*
DESCRIPTION	LOW PROFILE HIGH-BAY	8' LINEAR STRIP W/ ROUND LENS	8' WET-RATED LINEAR STRIP	4' WET-RATED LINEAR STRIP	ARCHITECTURAL WALL MOUNT	FULL-CUT-OFF POLE LIGHT	FULL-CUT-OFF POLE LIGHT
LIGHT SOURCE	LED	LED	LED	LED	LED	LED	LED
CRI PERFORMANCE	80 CRI	80 CRI	80 CRI	80 CRI	70 CRI	70 CRI	70 CRI
COLOR TEMPERATURE (K)	5000K	5000K	5000K	5000K	5000K	5000K	5000K
SUGGESTED WATTAGE	174W	86W	100W	60W	86W	VARIES*	VARIES*
DIMMING CAPABLE	YES	YES	YES	YES	YES	YES	YES
EMERGENCY CAPABLE	YES	YES	YES	YES	YES	YES	YES
FIXTURE FINISH	WHITE w/ NARROW OPTIC FROSTED LENS	WHITE w/ FROSTED LENS	WHITE w/ ACRYLIC LENS	WHITE w/ ACRYLIC LENS	DARK PLATINUM	DARK PLATINUM	DARK PLATINUM
MOUNTING	CABLE SUSPENSION	CABLE SUSPENSION	SUSPENDED OR SURFACE MOUNT	SUSPENDED OR SURFACE MOUNT	WALL MOUNT	POLE MOUNT SINGLE	POLE MOUNT - BACK TO BACK
NOTES	FIXTURES SHALL BE HUNG AT 20' AFF AND ARRANGED BETWEEN SERVICE BAYS TO PREVENT SHADOWING	FIXTURES SHALL BE HUNG AT 10' AFF OVER WORK BENCH AREAS	USE AS NEEDED IN ANY WET LOCATION AREA	USE AS NEEDED IN ANY WET LOCATION AREA	*SPECIFICATION VARIES DEPENDING UPON SITE CONDITIONS & LOCAL LIGHTING REGULATIONS - PHOTOMETRIC SURVEY SHALL ASSIST IN DETERMINING FINAL PART #	*SPECIFICATION VARIES DEPENDING UPON SITE CONDITIONS & LOCAL LIGHTING REGULATIONS - PHOTOMETRIC SURVEY SHALL ASSIST IN DETERMINING FINAL PART #	*SPECIFICATION VARIES DEPENDING UPON SITE CONDITIONS & LOCAL LIGHTING REGULATIONS - PHOTOMETRIC SURVEY SHALL ASSIST IN DETERMINING FINAL PART #

ARCHITECT / ENGINEER NOTES:

1. ALL LIGHTING SCHEDULES MUST INCLUDE THE FOLLOWING CONTACT INFORMATION

PRICING & SPECIFICATION ASSISTANCE
 DAN RODRIGUEZ - CED AUTOMOTIVE
 dan.rodriguez@cedslc.com / 562.964.5995

2. ALL FIXTURE PART #'s MUST INCLUDE THE PREFIX **RTN** TO GUARANTEE NATIONAL ACCOUNT PRICING
 EXAMPLE:
 TYPE F1 - **RTN**-HC615D010-HM612840-61WDH

These drawings are for communication of design intent only. These drawings are not suited or intended for construction or fabrication.

LIGHTING SCHEDULE

A 502



PRO™

Prototypical Details

FIXTURE TYPE	X1	X2	X3	X4	X5	X6	X7
LOCATION	FRONT OF HOUSE EXIT SIGNAGE	FRONT OF HOUSE EXIT SIGNAGE	BACK OF HOUSE EXIT SIGNAGE	EXIT & EGRESS COMBINATION	WET LOCATION EXIT SIGNAGE	INTERIOR EGRESS	EXTERIOR EGRESS - EXIT DOORS
FIXTURE PART #	RTN-APXEL71R	RTN-APXEL72R	RTN-LPX7SD	RTN-LPXC25SD	RTN-LPXW71RWHS	RTN-SEL50SD	RTN-SELDWA29SD
DESCRIPTION	EDGE LIT EXIT SIGN SINGLE FACE	EDGE LIT EXIT SIGN DUAL FACE	UNIVERSAL FACE EXIT SIGN	DUAL-HEAD EGRESS UNIT W/ EXIT SIGN	WET RATED EXIT SIGN	DUAL-HEAD EGRESS UNIT	ARCHITECTURAL EGRESS UNIT
LIGHT SOURCE	LED	LED	LED	LED	LED	LED	LED
CRI PERFORMANCE	N/A	N/A	N/A	N/A	N/A	N/A	N/A
COLOR TEMPERATURE (K)	N/A	N/A	N/A	N/A	N/A	N/A	N/A
SUGGESTED WATTAGE	4.1W	4.1W	1.12W	3.2W	3.4W	3.2W	1.1W
DIMMING CAPABLE	N/A	N/A	N/A	N/A	N/A	N/A	N/A
EMERGENCY CAPABLE	YES	YES	YES	YES	YES	YES	YES
FIXTURE FINISH	WHITE w/ RED LETTERS	WHITE w/ RED LETTERS	WHITE w/ RED LETTERS	WHITE w/ RED LETTERS	WHITE w/ RED LETTERS	WHITE HOUSING	SILVER HOUSING
MOUNTING	UNIVERSAL SURFACE MOUNT	UNIVERSAL SURFACE MOUNT	UNIVERSAL SURFACE MOUNT	SURFACE MOUNT	SURFACE MOUNT	SURFACE MOUNT	SURFACE MOUNT
NOTES							

ARCHITECT / ENGINEER NOTES:

- ALL LIGHTING SCHEDULES MUST INCLUDE THE FOLLOWING CONTACT INFORMATION

PRICING & SPECIFICATION ASSISTANCE
DAN RODRIGUEZ - CED AUTOMOTIVE
dan.rodriguez@cedslc.com / 562.964.5995
- ALL FIXTURE PART #'s MUST INCLUDE THE PREFIX **RTN** TO GUARANTEE NATIONAL ACCOUNT PRICING
EXAMPLE:
TYPE F1 - **RTN**-HC615D010-HM612840-61WDH

These drawings are for communication of design intent only. These drawings are not suited or intended for construction or fabrication.


LIGHTING SCHEDULE

A 503



PRO™

Prototypical Details

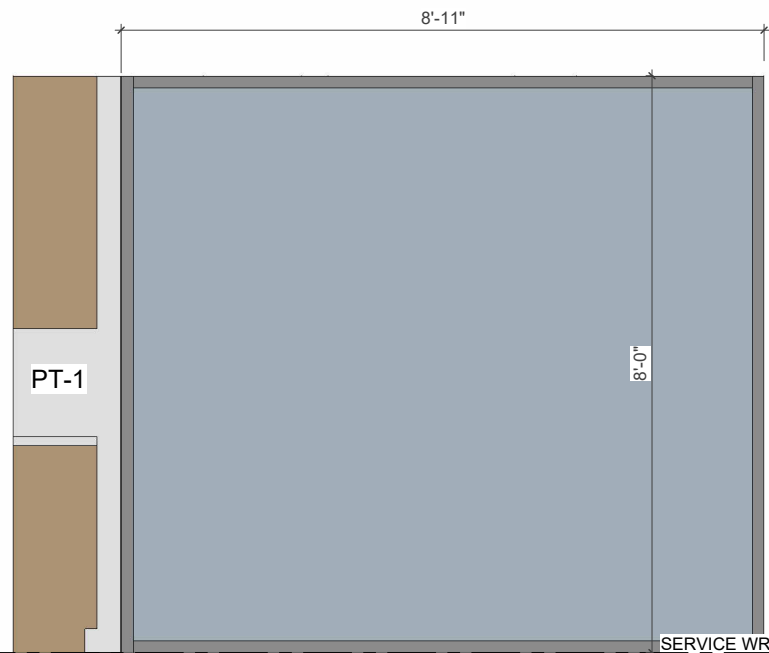


SERVICE WRITER PODIUM PLAN
0'-0"

FILLER (TOP & SIDES): LAM-1 ON 3/4" MDF CONSTRUCTION

UPPER WALL CABINETS WITH 2 ADJUSTABLE SHELVES: LAM-1 ON 3/4" MDF CONSTRUCTION WITH CONCEALED HINGES & MAGNETIC LATCH. PROVIDE LED STRIP LIGHTING UNDER CABINETS.

GYPSUM BOARD


BASE CABINETS: LAM-1 ON 3/4" MDF CONSTRUCTION WITH SS-1 COUNTERTOP. CONCEALED HINGES & MAGNETIC LATCH

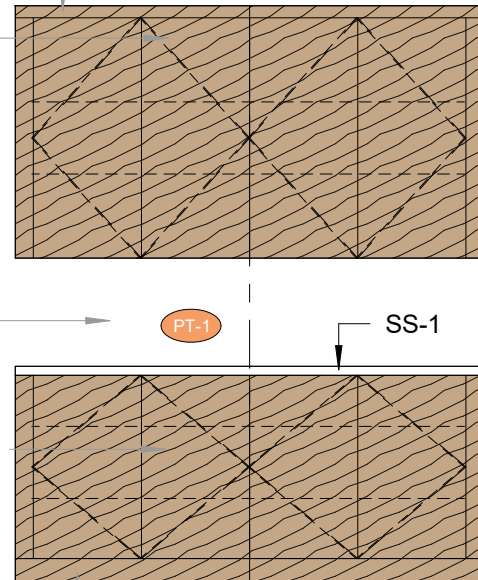

4" TOE KICK


4 | SERVICE WRITER GLASS PARTITION
3/8" = 1'-0"

3 | SERVICE WRITER MILLWORK ELEVATION
3/8" = 1'-0"

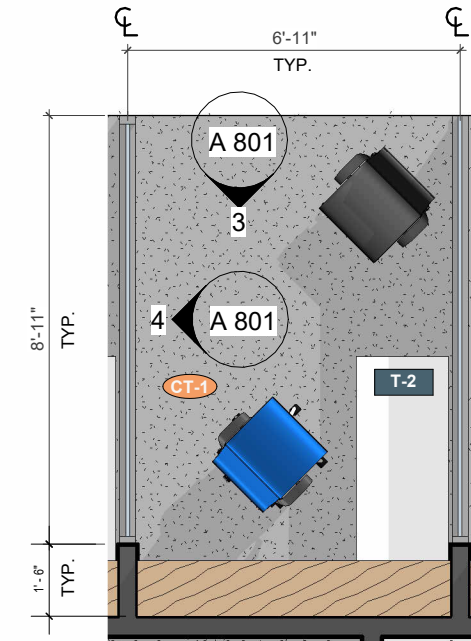

2 | SERVICE WRITER PLAN
1/4" = 1'-0"

These drawings are for communication of design intent only. These drawings are not suited or intended for construction or fabrication.

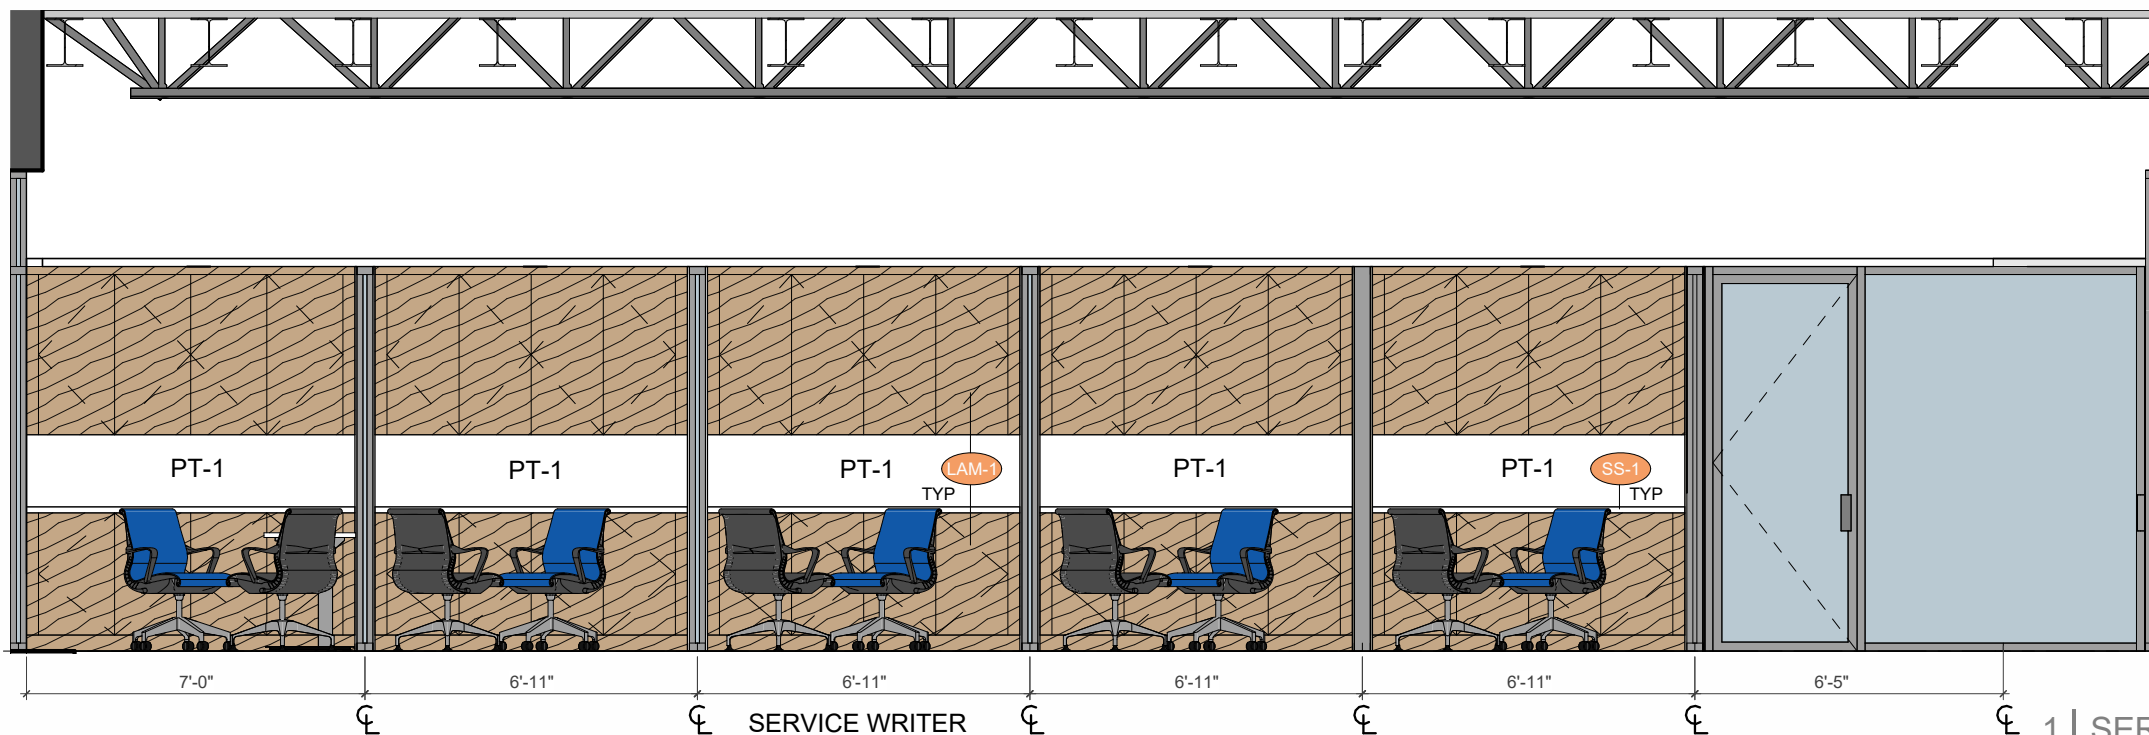

SERVICE WRITER

1 | SERVICE WRITER ELEVATION
1/4" = 1'-0"

SERVICE WRITE-UP -
DETAILS

A 801

EVIEW360

SYMBOL LEGEND

- xx-1 FINISHES
- xx-1 PLUMBING FIXTURES

GENERAL NOTES

- IF RENOVATION, SERVICE DEPARTMENT FLOOR TO BE CLEANED OR REPAIRED AS NECESSARY. OPTIONAL FLOOR FINISHES ARE INDICATED ON SHEET M300.
- REFER TO SHEET M 300 FOR FINISHES.
- REFER TO SHEET E 100 & E 200 FOR SERVICE EQUIPMENT.

BAY FLOOR CONSIDERATIONS

- CONCRETE THICKNESS TO BE DESIGNED BY ARCHITECT.
- SLOPE/ DIRECTION TO BE 1/8" PER FOOT TO REAR OF BAY OR DRAIN.
- DRAIN LOCATIONS ARE RECOMMENDED AT THE REAR OR CENTER OF THE BAY.

SIZE OF BAY

- BASIC SIZE - LIGHT TRUCK : 14'x30' (MINIMUM).
- DISTANCE BETWEEN OBSTRUCTIONS 3' MINIMUM. THIS WILL ALLOW TECHNICIAN TO WORK IN A EFFICIENT MANNER AROUND THE VEHICLE AND MOVING TIRES AND OTHER EQUIPMENT AROUND THE VEHICLE IN THE BAY.
- END BAY: ADD 3' ALONG THE WALL FOR TECHNICIAN CIRCULATION.
- MEDIUM DUTY TRUCK: 16'x40' FOR A 2 POST OR 18'x40' FOR A 4 POST (MINIMUM).
- SAFETY ZONE: 3' RECOMMENDED ALONG END WALL.
- * NOTE: NO MATTER WHAT THE INTENDED USE IS FOR THE BAY THE FOLLOWING OBSTRUCTIONS MUST BE CONSIDERED: COLUMNS, CURBS, LOW WALLS, SAFETY POSTS AND OVERHEAD DOOR RETURNS.

AISLES

- CENTER AISLE DRIVE-THROUGH: 24' WIDE MINIMUM FOR LIGHT TRUCK BAYS.
- CENTER AISLE DRIVE-THROUGH: 40' WIDE MINIMUM FOR MEDIUM/ HEAVY TRUCK BAYS.
- CENTER AISLE WALK-THROUGH: SEE CODES/ HANDRAILS.

CLEARANCE ABOVE BAYS

- 16' LIGHT DUTY TRUCKS
- 20' MEDIUM DUTY TRUCKS.
- * THESE HEIGHTS INCLUDE 2' ALLOWANCE FOR MECHANICALS.

EV/ POWER CONSIDERATIONS


AT EVERY OTHER BAY PROVIDE NEMA 1450 OUTLET UP TO A MAXIMUM OF 10 OUTLETS WITH ONE ADDITIONAL OUTLET AT THE SERVICE DRIVE OR CUSTOMER PARKING TO USE WITH EV CHARGER.

MODEL E ENROLLED FACILITIES

- 1 - LEVEL 3 DUAL PORT VEHICLE CHARGER FOR EVERY 20 BAYS OR
- 1 - LEVEL 2 VEHICLE CHARGER FOR EVERY 10 BAYS
- THIS REQUIREMENT IS FOR DEALERS THAT HAVE SIGNED UP FOR MODEL E ONLY



Prototypical Details

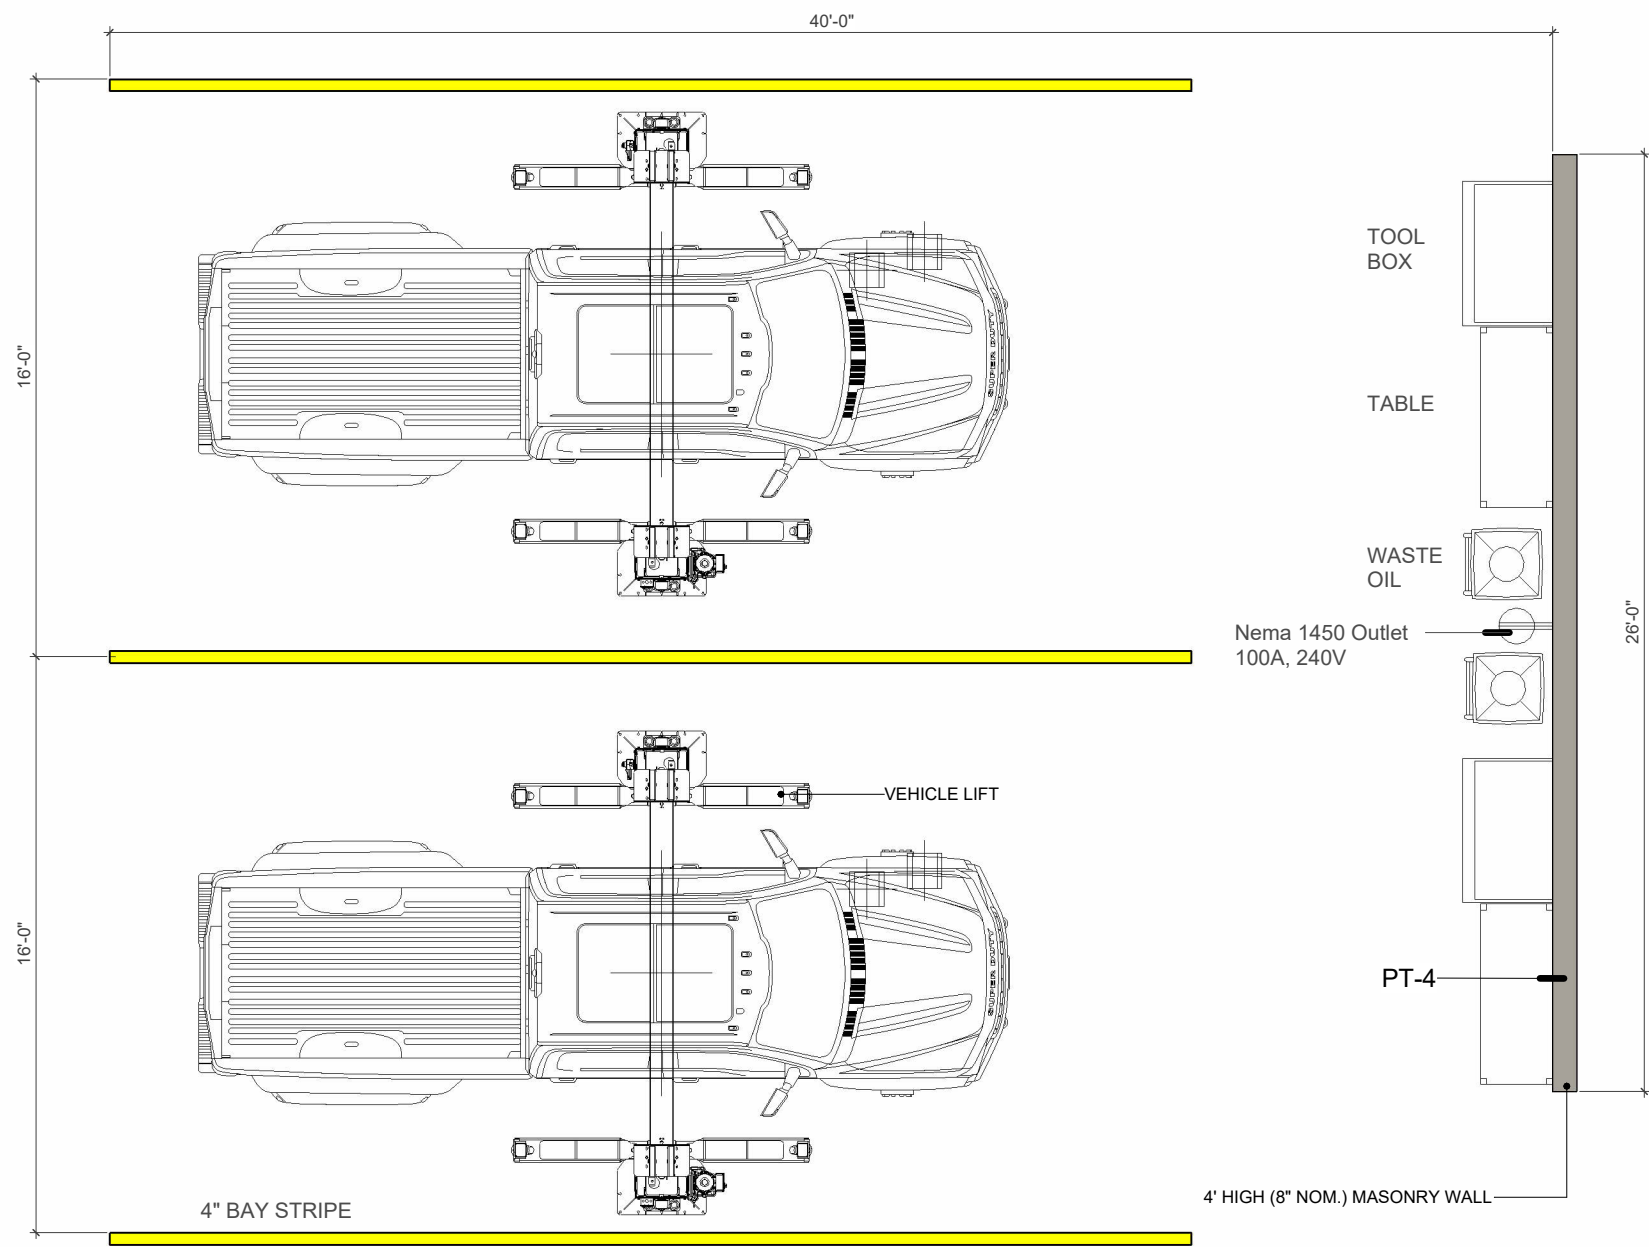

1 | TYP. SERVICE BAY/ EQUIPMENT
3/16" = 1'-0"

Scale As indicated


These drawings are for communication of design intent only. These drawings are not suited or intended for construction or fabrication.

SERVICE BAY


A 803



Prototypical Details

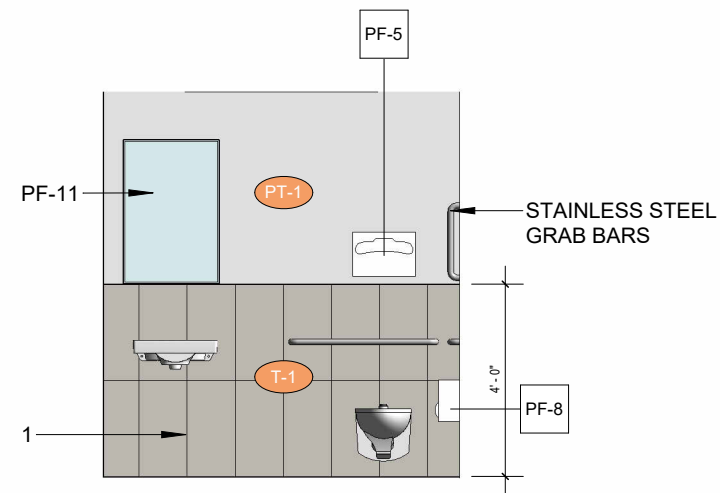

2 | RECEPTION RESTROOM
1/4" = 1'-0"

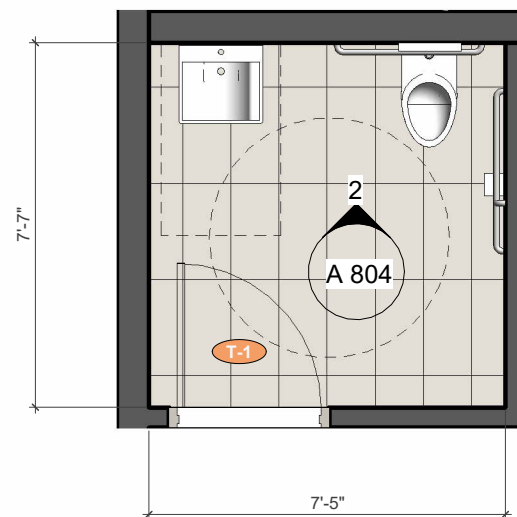

1 | FIRST FLOOR TOILET ROOM
1/4" = 1'-0"

SHEET NOTES

- ① ALIGN GROUT JOINTS, FLOOR AND WALL.
- ② STAINLESS STEEL FRAMED MIRROR
- ③ WALL TILE (T-1) TO BE PLACED ON ALL FOUR SIDES OF RESTROOM.

GENERAL NOTES

- SEE SHEET M300 FOR INTERIOR FINISH SCHEDULE
- RESTROOM LAYOUTS AND PLUMBING FIXTURE LOCATIONS TO COORDINATE WITH LOCAL CODE AND MEP REQUIREMENTS.
- FIXTURE COUNT FOR ALL PUBLIC RESTROOMS, STAFF RESTROOMS, AND TECH. LOCKERS PER LOCAL CODE REQUIREMENTS.
- VERIFY AND COORDINATE ALL POWER REQUIREMENTS.
- ALL FIXTURES AND MILLWORK SURFACES TO MEET LOCAL ACCESSIBILITY CODE, WHERE REQUIRED.
- SEE SHEET A 805 FOR RESTROOM FIXTURE SCHEDULE.
- COMPATIBLE TOUCHLESS FIXTURES WILL BE CONSIDERED UPON FORD APPROVAL.

SYMBOL LEGEND

- xx-1 FINISHES
- xx-1 PLUMBING FIXTURES

Scale As indicated

These drawings are for communication of design intent only. These drawings are not suited or intended for construction or fabrication.

FIRST FLOOR
RESTROOM - DETAILS

A 804

DRINKING FOUNTAIN



MFG
Elkay

MODEL
EDFPBM117RAC

No Lead Two-level Swirlflo
Wall Mount, Barrier-free Access
Polished / Unpolished

CONTACT
630-574-8484
www.elkayusa.com

LAVATORY



MFG
American Standard

MODEL
Decorum 9134001EC.020

COLOR
White

CONTACT
www.americanstandard-us.com
800-422-1902

FAUCET



MFG
Kohler


Single-Control Lavatory Faucet

MODEL
K-97282-4-CP

COLOR
Polished Chrome

CONTACT
800-4KOHLER
www.us.kohler.com

TOILET PARTITIONS

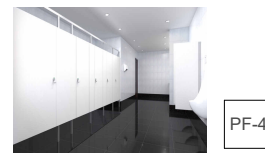


MFG
Scranton Products

MODEL
Eclipse Partitions

COLOR
White

CONTACT
1-866-753-4959
www.scrantonproducts.com

 SEAT COVER DISPENSER



MFG
Bradley

COLOR
5831

COLOR
Stainless Steel (Satin Finish)

CONTACT
800-BRADLEY
www.bradleycorp.com

MIRROR



MFG
Bradley

MODEL
740-018300

COLOR
Stainless Steel (Satin Finish)

CONTACT
800-BRADLEY
www.bradleycorp.com

URINAL



MFG
American Standard

MODEL
Pintbrook® 0.125 – 0.5 gpf (0.47 –
1.9 Lpf) Top Spud Urinal
#6002001.020

COLOR
White

Flush Valve
0.125 gpf Flush Valve: Sensor-
Operated:
American Standard Selectronic® #
6063.013.002
DC Power

CONTACT
www.americanstandard-us.com
800-422-1902

TOILET



MFG
American Standard

MODEL
Afwall® Millennium® 1.1 – 1.6 gpf
(4.2 – 6.0 Lpf) Top Spud
Elongated Wall-Hung EverClean®
Bowl
#3351101.020

COLOR
White

FLASH VALVE
1.6 gpf:
Sensor-Operated: American
Standard Selectronic®
DC Power #6065.161.002 (Top
Spud)
AC Power #6067.161.002 (Top
Spud)

CONTACT
www.americanstandard-us.com
800-422-1902

TOILET TISSUE DISPENSER



MFG
Bradley

MODEL
5402 - Bradex

Surface Mount, Dual Roll
Dispenser (Stainless Steel)

CONTACT
800-BRADLEY
www.bradleycorp.com

RECESSED PAPER TOWEL DISPENSER & WASTE RECEPTACLE



MFG
Bradley

MODEL
2297 - Bradex

Recessed

COLOR
Stainless Steel (Satin Finish)

CONTACT
800-BRADLEY
www.bradleycorp.com

SENSOR ACTIVATED HAND DRYER



MFG
American Specialties, Inc.

MODEL
20199

Semi-Recessed

COLOR
Stainless Steel (Satin Finish)

CONTACT
914-476-9000
www.americanspecialties.com

BABY CHANGING STATION



MFG
Koala Kare

MODEL
KB111 - SSRE

Recessed

COLOR
Stainless Steel (Satin Finish)

CONTACT
888-733-3456
www.koalabear.com


















Prototypical Details

Scale

*These drawings are for
communication of design intent
only. These drawings are not
suited or intended for
construction or fabrication.*

RESTROOMS FIXTURE
SCHEDULE

A 805

KIT #	IMAGE	ELEMENT	KIT #	IMAGE	ELEMENT	KIT #	IMAGE	ELEMENT	CONTACTS
CH-1		Lounge Chair	M-1		Mobile Pedestal	T-1		Occasional Table	MarxModa 751 Griswold Street Detroit, MI 48226 c: 989.277.9094 Melinda Kimmer fordretail@marxmoda.com
CH-2		Task Chair				T-2		Task Desk	
CH-3		Guest Chair				P-1 P-2 P-3		3' Podium 4' Podium 5' Podium	
CH-1		Lounge Chair	CH-5		Service Advisor Stool	T-1		Occasional Table	MFG Interiors 39255 Country Club Drive, Ste. B-11 Farmington Hills, MI 48331 orders@mfgint.com
CH-2		Task Chair				T-2		Task Desk	
CH-3		Guest Chair	M-1		Mobile Pedestal	P-1 P-2 P-3		3' Podium 4' Podium 5' Podium	



Prototypical Details

Scale

These drawings are for communication of design intent only. These drawings are not suited or intended for construction or fabrication.

KIT ELEMENTS AND CONTACTS

A 807

CORRUGATED METAL PANEL



MP-1

MFG
Arconic

SPECIFICATION
4" Horizontal Corrugated Metal Panel

COLOR
Castle Gray
(matches mindful grey)

LOCATION
Exterior Wall as indicated

CONTACT
Alisa Bollinger
alisa.bollinger@arconic.com
478-230-3600

ALT CORRUGATED METAL PANEL



MP-3

MFG
PAC-CLAD

SPECIFICATION
Profile - HWP

COLOR
Granite
(matches mindful grey)

LOCATION
Exterior Wall as indicated

CONTACT
Tony Sauve
tsauve@petersenmail.com
989-205-3531

EXTERIOR DARK GRAY PAINT



EP-1

MFG
Sherwin Williams


PRODUCT
SW A-100 Exterior acrylic latex seation A82 series

COLOR
Guantlet Grey SW7019

LOCATION
Exterior Paint

CONTACT
Dawn Cenowa
Dawn.M.Cenowa@Sherwin.com
248-660-3067

METAL PANEL

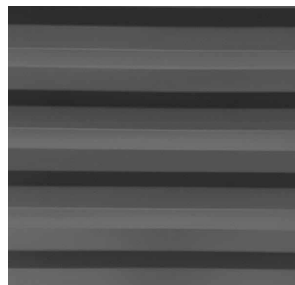

MP-2

MFG
Arconic

SPECIFICATION
4" Horizontal Corrugated Metal Panel

COLOR
Slate Grey
(matches gauntlet grey)

LOCATION
Exterior Wall as indicated

CONTACT
Alisa Bollinger
alisa.bollinger@arconic.com
478-230-3600

ALT METAL PANEL



MP-4

MFG
PAC-CLAD

SPECIFICATION
Profile - HWP

COLOR
Slate Gray
(matches gauntlet grey)

LOCATION
Exterior Wall as indicated

CONTACT
Tony Sauve
tsauve@petersenmail.com
989-205-3531

EXTERIOR LIGHT GRAY PAINT



EP-2

MFG
Sherwin Williams

PRODUCT
SW A-100 Exterior acrylic latex seation A82 series

COLOR
Mindful Grey SW7016

LOCATION
Exterior Paint

CONTACT
Dawn Cenowa
Dawn.M.Cenowa@Sherwin.com
248-660-3067

GLASS AND STOREFRONT FRAME



EG-1

MFG
Glass: PPG
Frame: Kawneer

SPECIFICATION
Glass: Solarban 60
Frame: Trifab 451UT (verify hurricane resistance as needed)

COLOR
Clear Anodized

LOCATION
Entrance Storefront/ Windows

CONTACT
Glass:
Joseph Sennese
jsennese@vitro.com
888-774-4332
Frame:
Kawneer
DESCRIPTION: Expressed mullions
Regional solar needs may suggest alternate glass specifications (Ford approval required)



Prototypical Details

These drawings are for communication of design intent only. These drawings are not suited or intended for construction or fabrication.

Exterior Finish Schedule

M 200

INTERIOR PAINT



MFG
Sherwin Williams **PT-1**

PRODUCT
SW ProMar 200 Zero V.O.C.
Interior Latex EgShel, B20
Series

COLOR
Pure White SW 7005

LOCATION
Interior unless otherwise noted

CONTACT
Dawn M. Cenowa
dawn.m.cenowa@sherwin.com
248-660-3067

FORD BLUE ACCENT PAINT



MFG
Sherwin Williams **PT-2**

PRODUCT
SW ProMar 200 Zero V.O.C.
Interior Latex EgShel, B20
Series

COLOR
Custom SW Color: FMC001
Ford Blue 2022

LOCATION
Accent Walls as noted

CONTACT
Dawn M. Cenowa
dawn.m.cenowa@sherwin.com
248-660-3067

INTERIOR PAINT



MFG
Sherwin Williams **PT-3**

PRODUCT
SW ProMar 200 Zero V.O.C.
Interior Latex EgShel, B20
Series

COLOR
Mindful Grey SW 7016

LOCATION
Interior unless otherwise noted

CONTACT
Dawn M. Cenowa
dawn.m.cenowa@sherwin.com
248-660-3067

INTERIOR PAINT



MFG
Sherwin Williams **PT-4**

PRODUCT
SW ProMar 200 Zero V.O.C.
Interior Latex EgShel, B20
Series

COLOR
Gauntlet Grey SW 7019

LOCATION
Service Bay Walls (4' A.F.F.)
Exposed Lobby Deck & Steel

CONTACT
Dawn M. Cenowa
dawn.m.cenowa@sherwin.com
248-660-3067

COUNTER



MFG
Corian **SS-1**

STYLE
Solid Surface

COLOR

LOCATION
Service Writers

CONTACT
Sabrina Kassab
skassab@oldenkamp.com
(586) 980-2413



Prototypical Details

CARPET TILES



MFG
Shaw Contract **CT-1**

 
SPECIFICATION
Style: Color Frame Tile 5T081
Size: 24" x 24" Tile
Install: 1/4 Turn

COLOR
Mystic Grey 81515

LOCATION
Service Writers/ Reception/
Admin.

CONTACT
Nichole Pikur
www.shawcontract.com
nichole.pikur@shawcontract.com

WALL BASE



MFG
Johnsontite **WB-1**

 
SPECIFICATION
Rubber Wall Base

COLOR
6" Traditional Duracove
50 White W

LOCATION
Service Lobby & Breakroom

CONTACT
www.commercial.tarkett.com

CONCRETE FLOORING




SPECIFICATION
Style: Poured In Place,
Steel Trowel
Finish.
Sealer to Protect From
Grease. **CN-1**

COLOR
Sherwin Williams
Armorseal Rextthane I
Clear, Gloss

LOCATION
Throughout Unless
Otherwise Noted

NOTE
Control Joints 20'-0"
O.C. As Required

 RESTROOM FLOOR TILE



MFG
Virginia Tile **T-1**

SPECIFICATION
Ceramic/ Matte Finish/
Rectified
Size: 12"x 24"
Grout: Custom Building
Products #

COLOR
Caesar Tiles/ Clash Spirit
CAEESP1224R Matt

LOCATION
Restrooms

CONTACT
Stephan Reinig
800-514-8453

ALT RESTROOM FLOOR TILE



MFG
Virginia Tile **T-2**

SPECIFICATION
VTIL Collection

 
COLOR
Waston Silver VTL
WT SI

Grout
TEC Dove Gray 908

LOCATION
Restrooms

CONTACT
Stephan Reinig
800-514-8453

CEILING TILE



MFG
Armstrong **AC-1**

 
SPECIFICATION
Acoustical Ceiling Tile

COLOR
Calla/ White

LOCATION
Offices, Restrooms, as
indicated

CONTACT
877-ARMSTRONG

CEILING GRID



MFG
Armstrong **CG-1**

 
SPECIFICATION
Acoustical Ceiling Tile

COLOR
Prelude XL 15/16"
exposed tee system
White

LOCATION
As indicated by ACT
color

CONTACT
877-ARMSTRONG

WOOD LAMINATE



MFG
Wilsonart **LAM-1**

SPECIFICATION
Wood Laminate
Finish: Softgrain

COLOR
Landmark Wood
7981K-12

LOCATION
All Millwork

CONTACT
Leslie Humpries
800-433-3222
www.wilsonart.com

ALT WOOD LAMINATE



MFG
Formica **LAM-2**

SPECIFICATION
Wood Laminate
Finish: Natural Grain

COLOR
Cascara Teakwood 8909-NG

LOCATION
All Millwork

CONTACT
800-367-6422
https://www.formica.com/en-us

*These drawings are for
communication of design intent
only. These drawings are not
suited or intended for
construction or fabrication.*

Interior Finish Schedule

M 300

Rotunda is the preferred service tool and equipment provider for Ford Motor Company dealerships and offers service and business products that assure Ford and Lincoln vehicles can be serviced properly on the first visit.



ROTUNDA



Area Sales Manager Regional Contacts

Have a discussion with your ASM today to have them customize your Commercial Vehicle Center to your needs.


Talk To Us:

- Within the United States: **1-800-ROTUNDA** (800-768-8632)
- Diagnostic Software License Subscriptions including IDS: **Option #1**
- Keys, Diagnostic Hardware, General Service Equipment and Rotunda Dealership Supplies: **Option #2**
- Essential Special Service Tools: **Option #3**
- Rotunda Technician Tool Program: **Option #4**

Email Us:

Customer Care for Diagnostic Hardware, GSE and RDS: rotunda@service-solutions.com

Customer Care for Essential Special Service Tools: otc@service-solutions.com

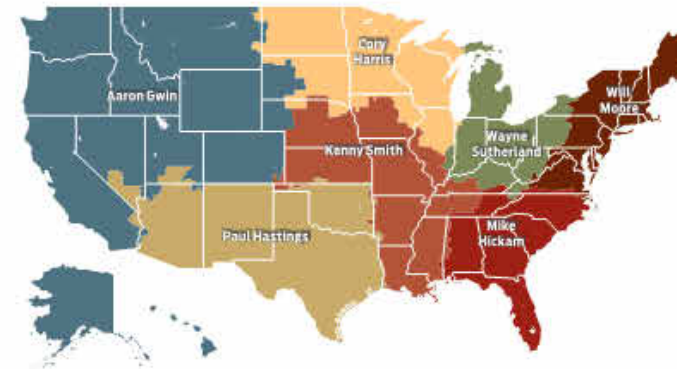

MOUNTAIN/WEST/ALASKA
Aaron Gwin
510-421-5190
Agwin1@ford.com

SOUTHWEST
Paul Hastings
936-727-1841
Phastin6@ford.com

NORTH CENTRAL
Cory Harris
224-257-1570
Charr368@ford.com

CENTRAL
Kenny Smith
504-258-4728
Ksmit544@Ford.com

NORTHEAST
Will Moore
908-210-1632
Wmoor137@Ford.com

SOUTHEAST
Mike Hickam
978-302-3122
Mhickam@Ford.com

GREAT LAKES
Wayne Sutherland
313-418-0227
Wsuther8@Ford.com

Prototypical Details

These drawings are for communication of design intent only. These drawings are not suited or intended for construction or fabrication.

Ford Rotunda

E 100

www.OneRotunda.com 1-800-ROTUNDA (768-8632)

Contact your Rotunda Area Sales Manager (ASM) for all your equipment and facility planning needs.



Rotunda Equipment Guide for F-650/750 Medium Duty Service

	Equipment Type	Supplier	Rotunda Part #	Description
SELECT ONE	Mobile Columns Lift	Challenger	223-CLHM-135-4	(4) Mobile Column Lifts - Combined 54,000-lb. Capacity
	Mobile Columns Lift	Challenger	223-CLHM-185-4	(4) Mobile Column Lifts - Combined 74,000-lb. Capacity
	Mobile Columns Lift	Rotary	138-MCH413	(4) Mobile Column Lifts - Combined 52,000-lb. Capacity
	Mobile Columns Lift	Rotary	138-MCHW41B	(4) Mobile Column Lifts - Combined 72,000-lb. Capacity
	Mobile Columns Lift	Rotary	138-MCH41B	(4) Battery Operated Mobile Column Lifts - Combined 72,000-lb. Capacity
	HD 4-Post Lift	Rotary/Challenger	Several	Several 4-Post Options Available. Contact your Rotunda ASM for Assistance
SELECT ONE	Floor Jack	Norco	209-71500E	5-Ton Capacity Floor Jack
	Floor Jack	Norco	209-71000D	10-Ton Floor Jack
	Floor Jack	Norco	209-72212	12-Ton Axle Jack, Air/Hydraulic
	Floor Jack	Norco	209-72244	44-Ton Floor Jack, Air/Hydraulic
	Transmission Jack	OTC	014-5019A	Transmission Jack, Low-Lift, 2,200-lb. Capacity
	Small Jack Stand	Norco	209-81225I	(2) 25-Ton Jack Stands - 12"- 20" Height Range
	Medium Jack Stand	Norco	209-81209I	(2) 10-Ton Jack Stands - 18.5"- 30" Height Range
	Large Jack Stand	Norco	209-81210I	(2) 10-Ton Jack Stands - 28"- 47" Height Range
SELECT ONE	High Rise Jack Stand	Rotary	138-R518	18,000-lb. Portable High Rise Jack Stand - 56"- 82" Height Range
	High Rise Jack Stand	Challenger	223-CLHM-THR	18,000-lb. Portable High Rise Jack Stand - 46"- 84" Height Range
	HD Tire Changer	Hunter	006-TCX625HD	Compact Heavy-Duty Tire Changer
	HD Wheel Balancer	Hunter	006-FM02	ForceMatch Heavy-Duty Wheel Balancer Incl: Wheel Lift and TDC Laser
	Wheel Balancer Accessory	Hunter	006-20-2977-2	MD Large Bore Stud Kit (8-Lug, 19.5") Balancer Kit
	Wheel Balancer Accessory	Hunter	006-20-3116-1	MD Universal Wheel Balancing Centering Kit
	Wheel Balancer Accessory	Hunter	006-20-1937-1	MD Truck Wheel Balancer Kit
SELECT ONE	Wheel Lift	Norco	209-82305	Air Operated Tire and Wheel Lift - 300-lb. Capacity
	Wheel Lift	QSP	337-LM-350	Air Operated Tire and Wheel Lift - 350-lb. Capacity
SELECT ONE	Hydraulic Press	OTC	014-1833	25-Ton Shop Press
	Hydraulic Press	Norco	209-78024	25-Ton Shop Press
	Hydraulic Press Accessory Kit	OTC	014-1881	25-Ton Shop Press Accessory Kit (Works with OTC and Norco)
	Engine Stand	Norco	209-78200A	2,000-lb. Capacity Twin-Post Rotating Engine Stand
	Engine Stand Adapter	Norco	209-78203	6.7L Diesel Engine Stand Adapter
	Topside Creeper	Folding Traxion	TRX3-100 (RTTP)	Topside Creeper - Foldable, Easily Stored, and Slip Resistant
	Step Stool	ISN	300-STC20350E	The Pro Step (HD Mobile Step Platform)
	On-Car Brake Lathe	Pro Cut	201-A10-BASE-IBT	Warthog On-Car Brake Lathe (Base) (Trade-In Required)
	Lathe Accessory	Pro Cut	201-50-ACC	Accessory Package for Any PFM 9.2 or Warthog OCLs
	Lathe Accessory	Pro Cut	201-50-999KIT	OCL Medium Duty Truck Kit
	Aligner	Hunter	006-WT484DRE	HD Aligner Computer System (Many Different Configurations Available)
	Alignment Sensors	Hunter	006-DSP740T	(4) HD Alignment Sensors (Cordless)
	Alignment Rack	Hunter	006-RKHD	Power Rack with 24" Turn Plates (403" Length)
	Alignment Rack Extension	Hunter	006-20-1780-2	46" Extension Kit for RKHD Power Rack (Adds 46" of Length)
	Alignment Rack Jacks	Hunter	006-133-77-2	HD 32,500-lb. Capacity Rolling Jack for RKHD Rack

www.OneRotunda.com 1-800-ROTUNDA (768-8632)

Contact your Rotunda Area Sales Manager (ASM) for all your equipment and facility planning needs.



Equip Your Ford Pro™ Service Center with the tools to service Medium Duty Vehicles



Recommended F-650/750 Equipment

See page 2 for full list



The Rotunda Advantage for our Ford Pro™ Service Center Partners

- Exclusive Financing Terms for our Ford Pro™ Service Center Partners
- Bundle and save
- Assistance with facility planning and design with in-person consultation
- Professional architectural drawings assist with your installation
- Single point of contact ensures that all tools and equipment arrive on schedule
- Equipment tested and approved by Ford Engineering

Contact your Rotunda ASM for more info



Prototypical Details

These drawings are for communication of design intent only. These drawings are not suited or intended for construction or fabrication.

Ford Rotunda

E 200

www.OneRotunda.com 1-800-ROTUNDA (768-8632)

Contact your Rotunda Area Sales Manager (ASM) for all your equipment and facility planning needs.



General Notes

All signage to be purchased through Ford Retail Identification and installed by AGI (888-856-7880).

Dimensions are approximate and prices are subject to change.



Prototypical Details



- 1** 24" LED illuminated "Elite Commercial Service" letterset - **\$16,653.00**

- 2** 12" LED illuminated dealer name letters - **\$786.00 each**

- 3** Ford Blue ACM Wall Options:
 - Ford Blue ACM Wall 14'w x 16't (includes additional 4' ACM on side elevation, OV-31 Ford Oval, 24" PRO letters and Accent Bar) - **\$42,000.00**

 - Ford Blue ACM Wall 14'w x 20't (includes additional 4' ACM on side elevation, OV-31 Ford Oval, 24" PRO letters and Accent Bar) - **\$44,336.00**

 - Ford Blue ACM Wall 14'w x 24't (includes additional 4' ACM on side elevation, OV-31 Ford Oval, 24" PRO letters and Accent Bar) - **\$47,739.00**

 - Ford Blue ACM Wall 14'w x 28't (includes additional 4' ACM on side elevation, OV-31 Ford Oval, 24" PRO letters and Accent Bar) - **\$51,183.00**

- 4** Awning Options:
 - Grabber Blue Awning 3' in depth w/ down lighting over entry doorway per 12' sections - **\$5,760.00**

 - Grabber Blue Non-Illuminated 8" in depth Slim Awning per 12' sections - **\$3,798.00**

These drawings are for communication of design intent only. These drawings are not suited or intended for construction or fabrication.

Ford Brand Signs

G 101

PROJECT INFORMATION:

PROJECT MANAGER NAME
(XXX) XXX-XXXX

(QTY) CTF PANELS

SHEET LEGEND

C01	COVER
P01	PLANS/RCPS
E01	ELEVATIONS
S01	SECTIONS
D01	DETAILS

APPROVAL

DATE	NAME
	<input type="checkbox"/> APPROVED
	<input type="checkbox"/> APPROVED AS NOTED
	<input type="checkbox"/> REVISE & RESUBMIT

SPECIAL NOTES:

MATERIAL INFORMATION:

ACM SYSTEM: 1/4" RAINSCREEN

MP-1 4MM ALUMINUM COMPOSITE PANELS
RAPTURE BLUE
ALPOLIC A.S.U. - @ 62" X 196"

ADDITIONAL MATERIALS:

- | | |
|--|--|
| <input type="checkbox"/> PLYWOOD (3/4" CDX) | <input type="checkbox"/> SHEET METAL |
| <input type="checkbox"/> VAPROSHIELD - IT / SA | <input type="checkbox"/> SHEET METAL COPING |
| <input type="checkbox"/> 16 GA STRAPPING | <input type="checkbox"/> NON STD. SCREW |
| <input type="checkbox"/> BAFFLES/STUDS/FURRING | <input type="checkbox"/> ELECTRICAL COMPONENTS |
| <input type="checkbox"/> HIGH WIND LOAD / FBPA | <input type="checkbox"/> SIGNAGE |
| | <input type="checkbox"/> OTHER - SEE NOTES |

GLOSSARY OF TERMS

CTF = CUT TO FIT
ALL "CUT TO FIT" PANELS ARE SHIPPED FLAT FROM THE MANUFACTURER. THE MANUFACTURER ADDS 6" TO THE ASSUMED LENGTH. THE INSTALLER WILL BE RESPONSIBLE FOR CUTTING TO LENGTH AND FOLDING ALL RETURNS AND RIVETING THE EXTRUSIONS TO THE ACM. PANELS MUST BE FABRICATED IN COMPLIANCE WITH AGI STANDARD PROCEDURE.

TTF = TRIM TO FIT
ALL "TRIM TO FIT" PANELS WILL BE SHIPPED FROM THE MANUFACTURER WITH ALL EXTRUSIONS ATTACHED. THE INSTALLER WILL BE RESPONSIBLE FOR TRIMMING THE PANEL TO FIT THE DISSIMILAR MATERIAL. TRIM TO FIT PANELS WILL TYPICALLY REQUIRE A HEEL BEAD CAULK JOINT TO FINISH THE EDGE OF THE MATERIAL.

DNF = DO NOT FOLD
ALL "DNF" ROUTS ARE ROUTS THAT ARE NOT FOLDED AT THE MANUFACTURER. THIS WILL REQUIRE THE INSTALLER TO FOLD THE PANEL AND INSTALL CHEVRONS WITH RIVETS. ALL FACES THAT EXCEED 4" WILL TYPICALLY BE "DNF" UNLESS NOTED OTHERWISE. THE PURPOSE OF "DNF" ARE TO MINIMIZE THE NUMBER OF SHIPPING CRATES.

FASTENER LIBRARY: ATTACHMENT @ 16" O.C.

FASTENER #1: (T1) #8-18 3/4" HWH TEK	
FASTENER #2: (T8) #12-14 x 3" HWH TEK	
FASTENER #3: (T11) #12-14 x 1" HWH TEK	

GENERAL NOTES:

IMPORTANT CUSTOMER NOTES:

- ALL OF AGI'S SHOP FABRICATED MATERIAL WILL BE MANUFACTURED TO THE DIMENSIONS SHOWN UNLESS OTHERWISE NOTED.
- IT IS CRUCIAL THAT ANY NECESSARY CHANGES, NOTATIONS OR REQUESTED INFORMATION BE CLEARLY NOTED ON THE SHOP DRAWINGS AND RETURNED TO AGI FOR REVIEW.
- FIELD VERIFIED DIMENSIONS SHOULD BE INDICATED BY DENOTING "OK" OR "✓", OR BY NOTING THE CORRECT DIMENSION.
- WHERE AGI SPECIFICALLY REQUESTS TO "FIELD VERIFY" OR "SPECIFY A DIMENSION" THE PROPER CUSTOMER RESPONSE WILL BE TO:
 - A) MARK WITH EITHER "OK" OR VALIDATE WITH A CHECK MARK IF THE DIMENSION IS CORRECT.
 - OR
 - B) NOTE THE CORRECT DIMENSION.
- IT IS IMPERATIVE THAT FIELD DIMENSIONS ARE TAKEN TO ENSURE ACCURATE FABRICATION AND PROPER MATERIAL FIT.
- NO MATERIAL WILL BE CONSIDERED RELEASED FOR FABRICATION UNTIL ALL PERTINENT INFORMATION (i.e., COLOR, DIMENSIONS, MATERIAL CONFIGURATION) HAS BEEN RECEIVED AND AGREED UPON BY AGI.
- AGI MUST HAVE 'APPROVED' SHOP DRAWINGS WITH AUTHORIZATION TO RELEASE THE MATERIAL FOR FABRICATION AS INDICATED BY A CUSTOMER AUTHORIZATION SIGNATURE.

SYSTEM PANEL NOTES:

FOR ADDITIONAL SYSTEM INSTALLATION ASSISTANCE, CONTACT AGI ENGINEERING.

ALL PANEL CLIPS ARE TO BE FASTENED USING A MINIMUM #14 OR #12 FASTENER.

EXPOSED FASTENERS SHALL BE STAINLESS STEEL OR ALUMINUM RIVETS. ALL OTHER FASTENERS TO BE ZINC PLATED.

ATTACHMENT SPACING TO BE 16" o.c.

SEALANT NOTE:

SEALANTS TO BE APPLIED ACCORDING TO MANUFACTURER'S INSTALLATION GUIDELINES. USE A HIGH QUALITY SEALANT COMPATIBLE WITH CORAFLO, KYMAR AND POLYESTER FINISHES. AGI RECOMMENDS DOW 795 SUPPLIED AS NOTED IN SHOP DRAWINGS.

SHIMS NOTE:

SHIMS TO BE INSTALLED AS REQUIRED PER ACTUAL JOB-SITE CONDITIONS AND AS NOTED PER AGI SHOP DRAWINGS.

BACKER RODS NOTE:

BACKER RODS TO BE INSTALLED PER SHOP DRAWINGS

CTF PANELS:

ALL CTF PANELS NEED TO BE CAULKED AND SEALED IN CORNERS

ALUMINUM EXTRUSIONS:


EXTRUSIONS SUPPLIED ARE MADE FROM HIGH QUALITY 6063-T5 ALUMINUM UNLESS OTHERWISE NOTED.

MEASUREMENT NOTE:

ALL AREAS WHERE THIS MATERIAL IS USED WILL BE REQUIRED TO BE FIELD MEASURED PRIOR TO RELEASE FOR FABRICATION.

MOISTURE BARRIER NOTE:

MOISTURE BARRIER TO BE INSTALLED AND SUPPLIED AS NOTED IN SHOP DRAWINGS AND PER MANUFACTURER'S INSTALLATION GUIDELINES

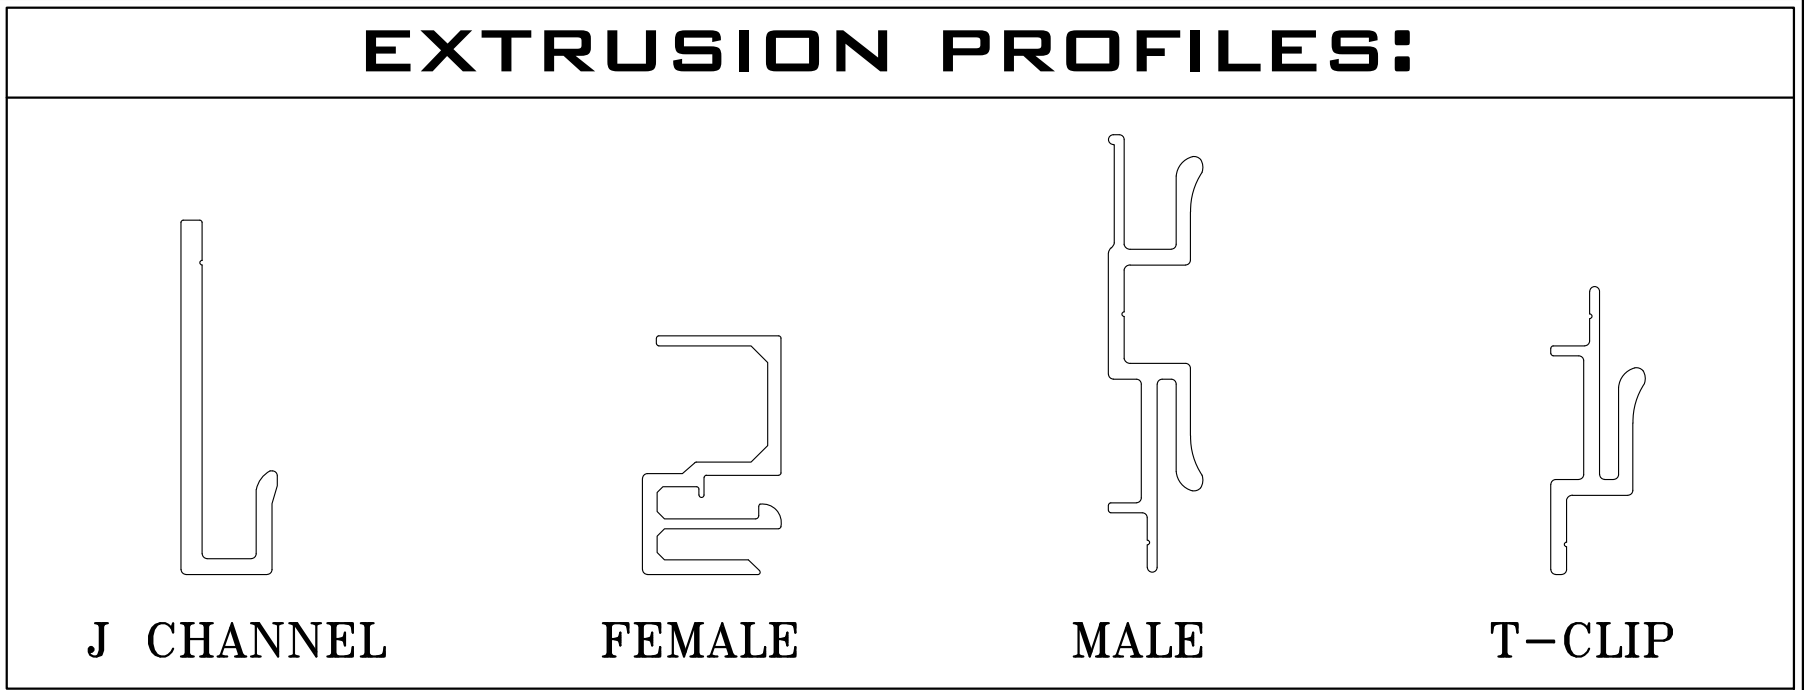

SQUARE FOOTAGES:

NOTE TO INSTALLER:

IT SHALL BE THE RESPONSIBILITY OF THE INSTALLER TO REVIEW AND PRE-DETERMINE THE ACM PANEL, AND CORRUGATION LAYOUT, PRIOR TO BEGINNING INSTALLATION OF THOSE ITEMS.





⊥ — xx — ⊥

DIMENSIONS SHOWN THUS, REPRESENT DESIGN CONSTRAINTS. ACTUAL DIMENSIONS WILL VARY SLIGHTLY. THE DIMENSIONS SHOWN ARE USED TO ASSURE ACM PANELS, AND REVEALS, ARE INSTALLED LEVEL AND PLUMB, IN ALL DIRECTIONS, BASED ON EXISTING FRAMING CONDITIONS.

REV #	DATE	COMMENTS
△		
△		
△		
△		
△		
△		

This document is the sole property of AGI, and all design, manufacturing, reproduction, use and sale rights regarding the same are expressly forbidden. It is authorized under no circumstances to be used for a special purpose, and the recipient, by accepting this document assumes custody and agrees that this document will not be copied or reproduced in whole or in part, nor its contents revealed in any manner or to any person except for the purpose for which it was tendered, nor any specific features peculiar to this design be incorporated in other projects.

 Approved By: _____
Date Approved: _____

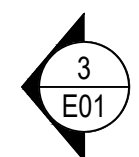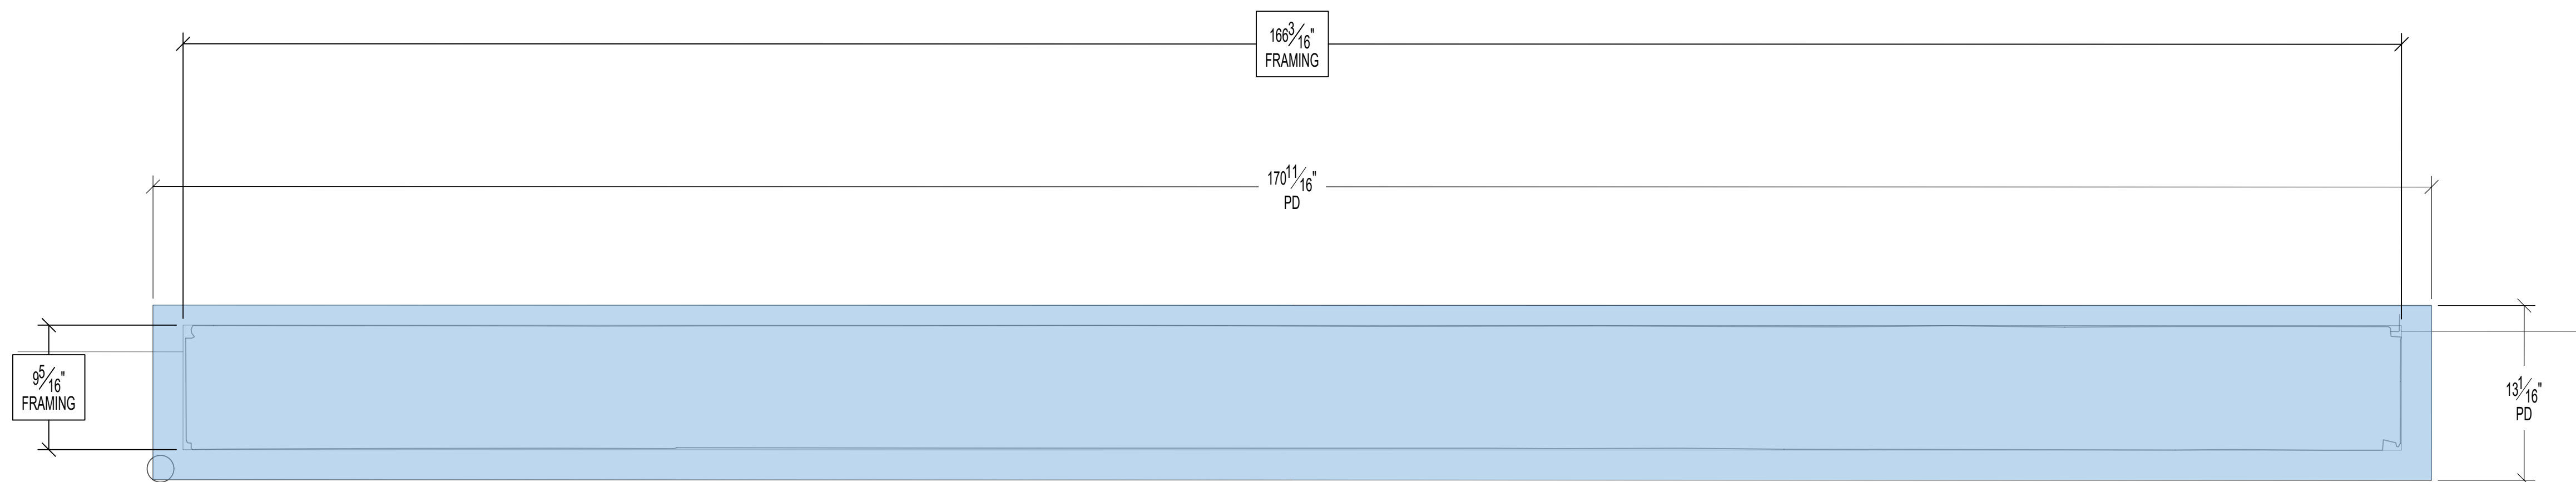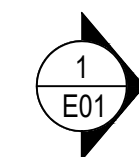

1 FORD PRO ROOF PLAN
P01 1-1/2"=1'-0"


PROJECT FORD PRO
HOMETOWN, USA
ARCHITECT

DRAWN BY AGI
JOB # FORD PRO
DATE 1/30/2023


REV #	DATE	COMMENTS
△		
△		
△		
△		
△		

This document is the sole property of AGI, and all design, manufacturing, reproduction, use and sale rights regarding the same are expressly forbidden. It is submitted under a confidential relationship, for a special purpose, and the recipient, by accepting this document assumes custody and agrees that this document will not be copied or reproduced in whole or in part, nor its contents revealed in any manner or to any person except for the purpose for which it was tendered, nor any special features peculiar to this design be incorporated in other projects.


Approved By: _____
Date Approved: _____

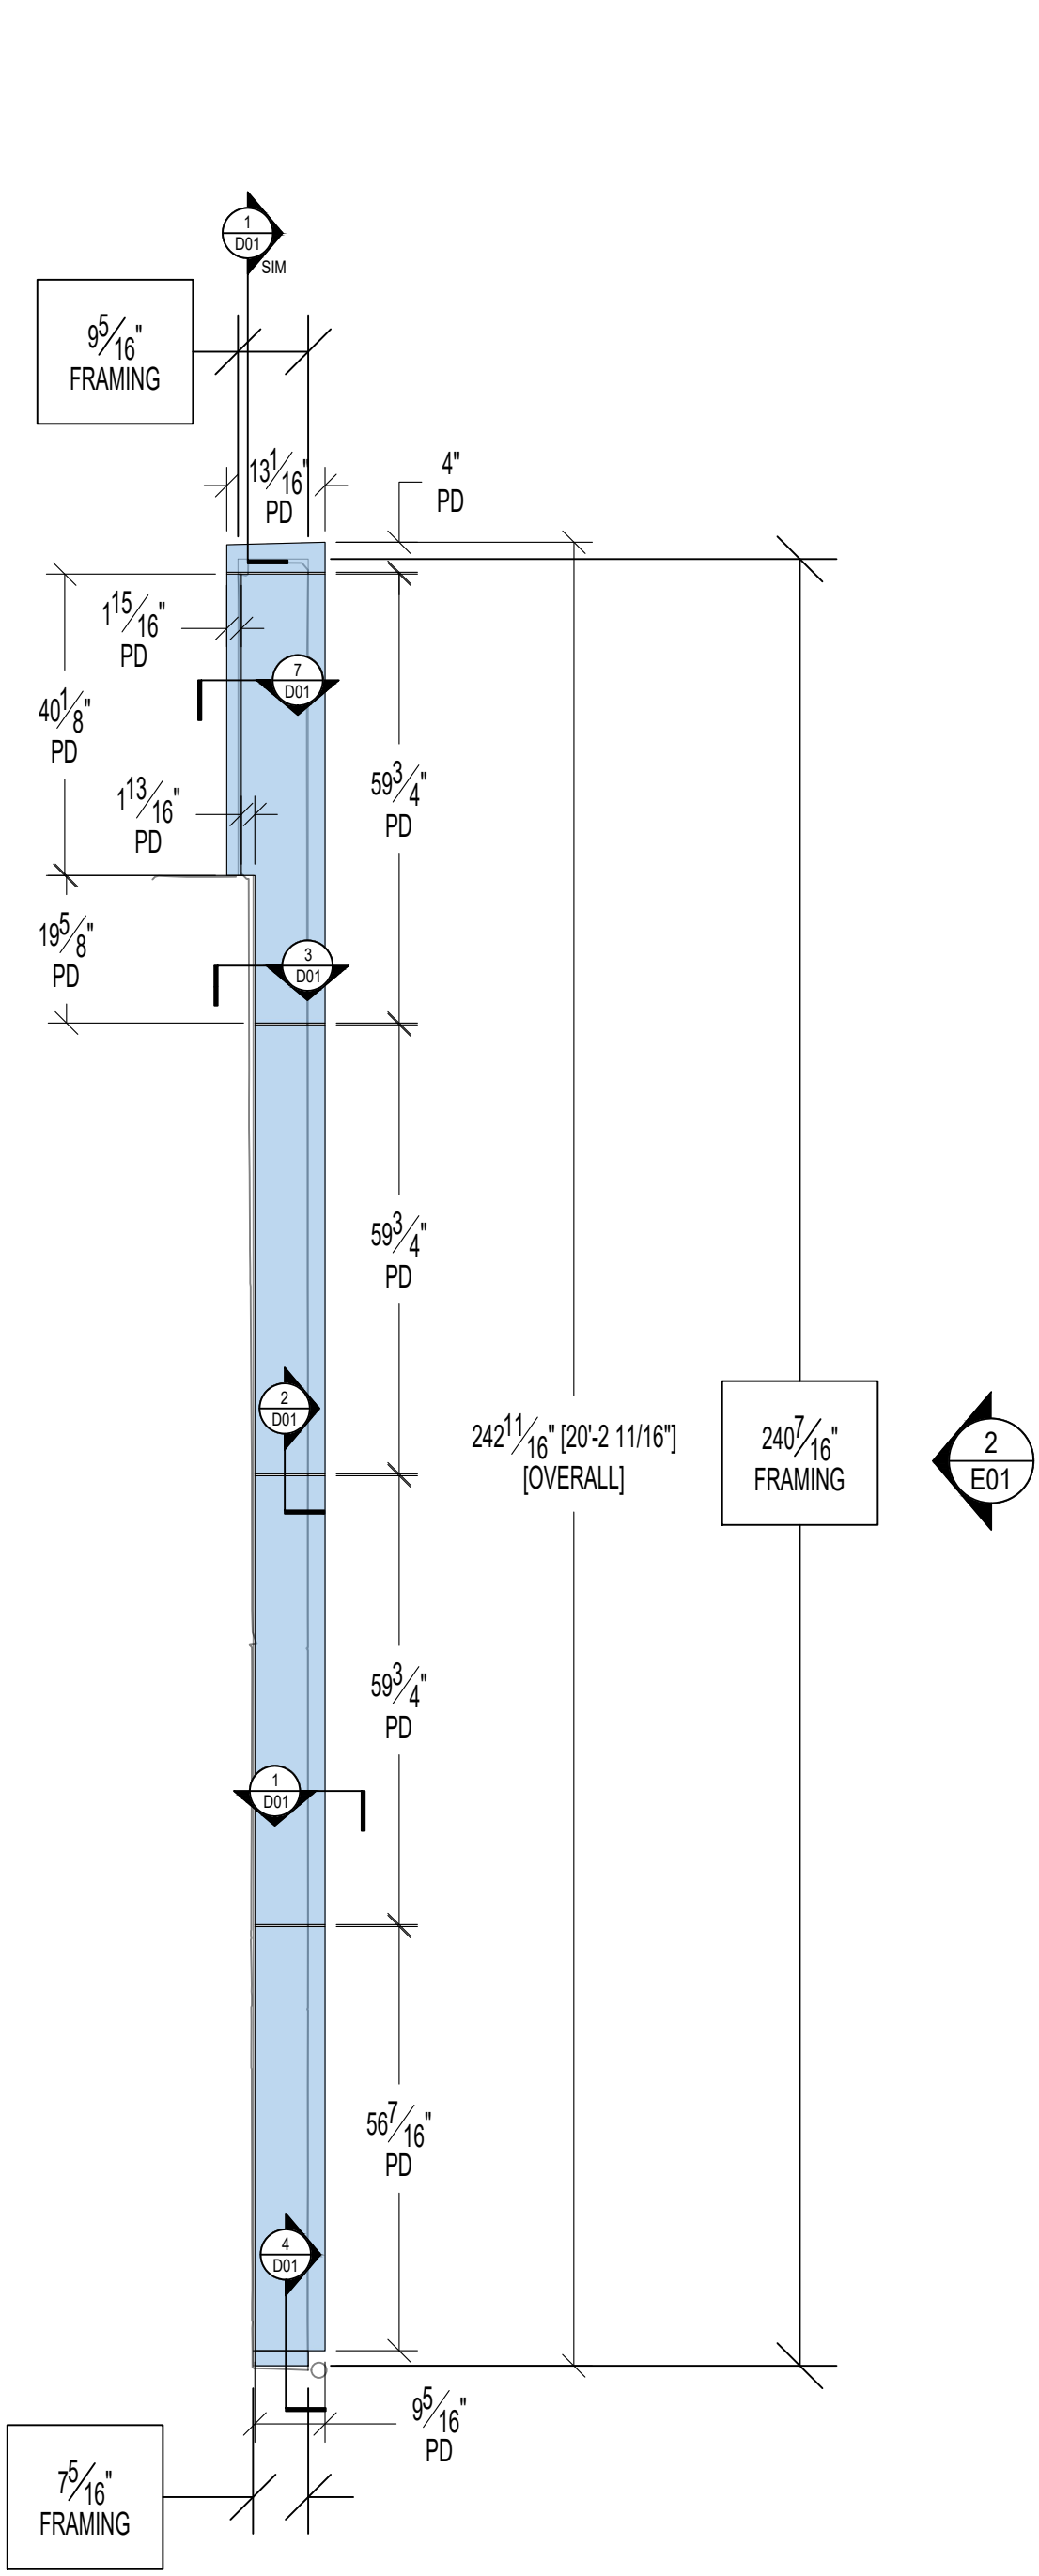

1 FORD PRO LEFT ELEVATION
E01 1/2"=1'-0"

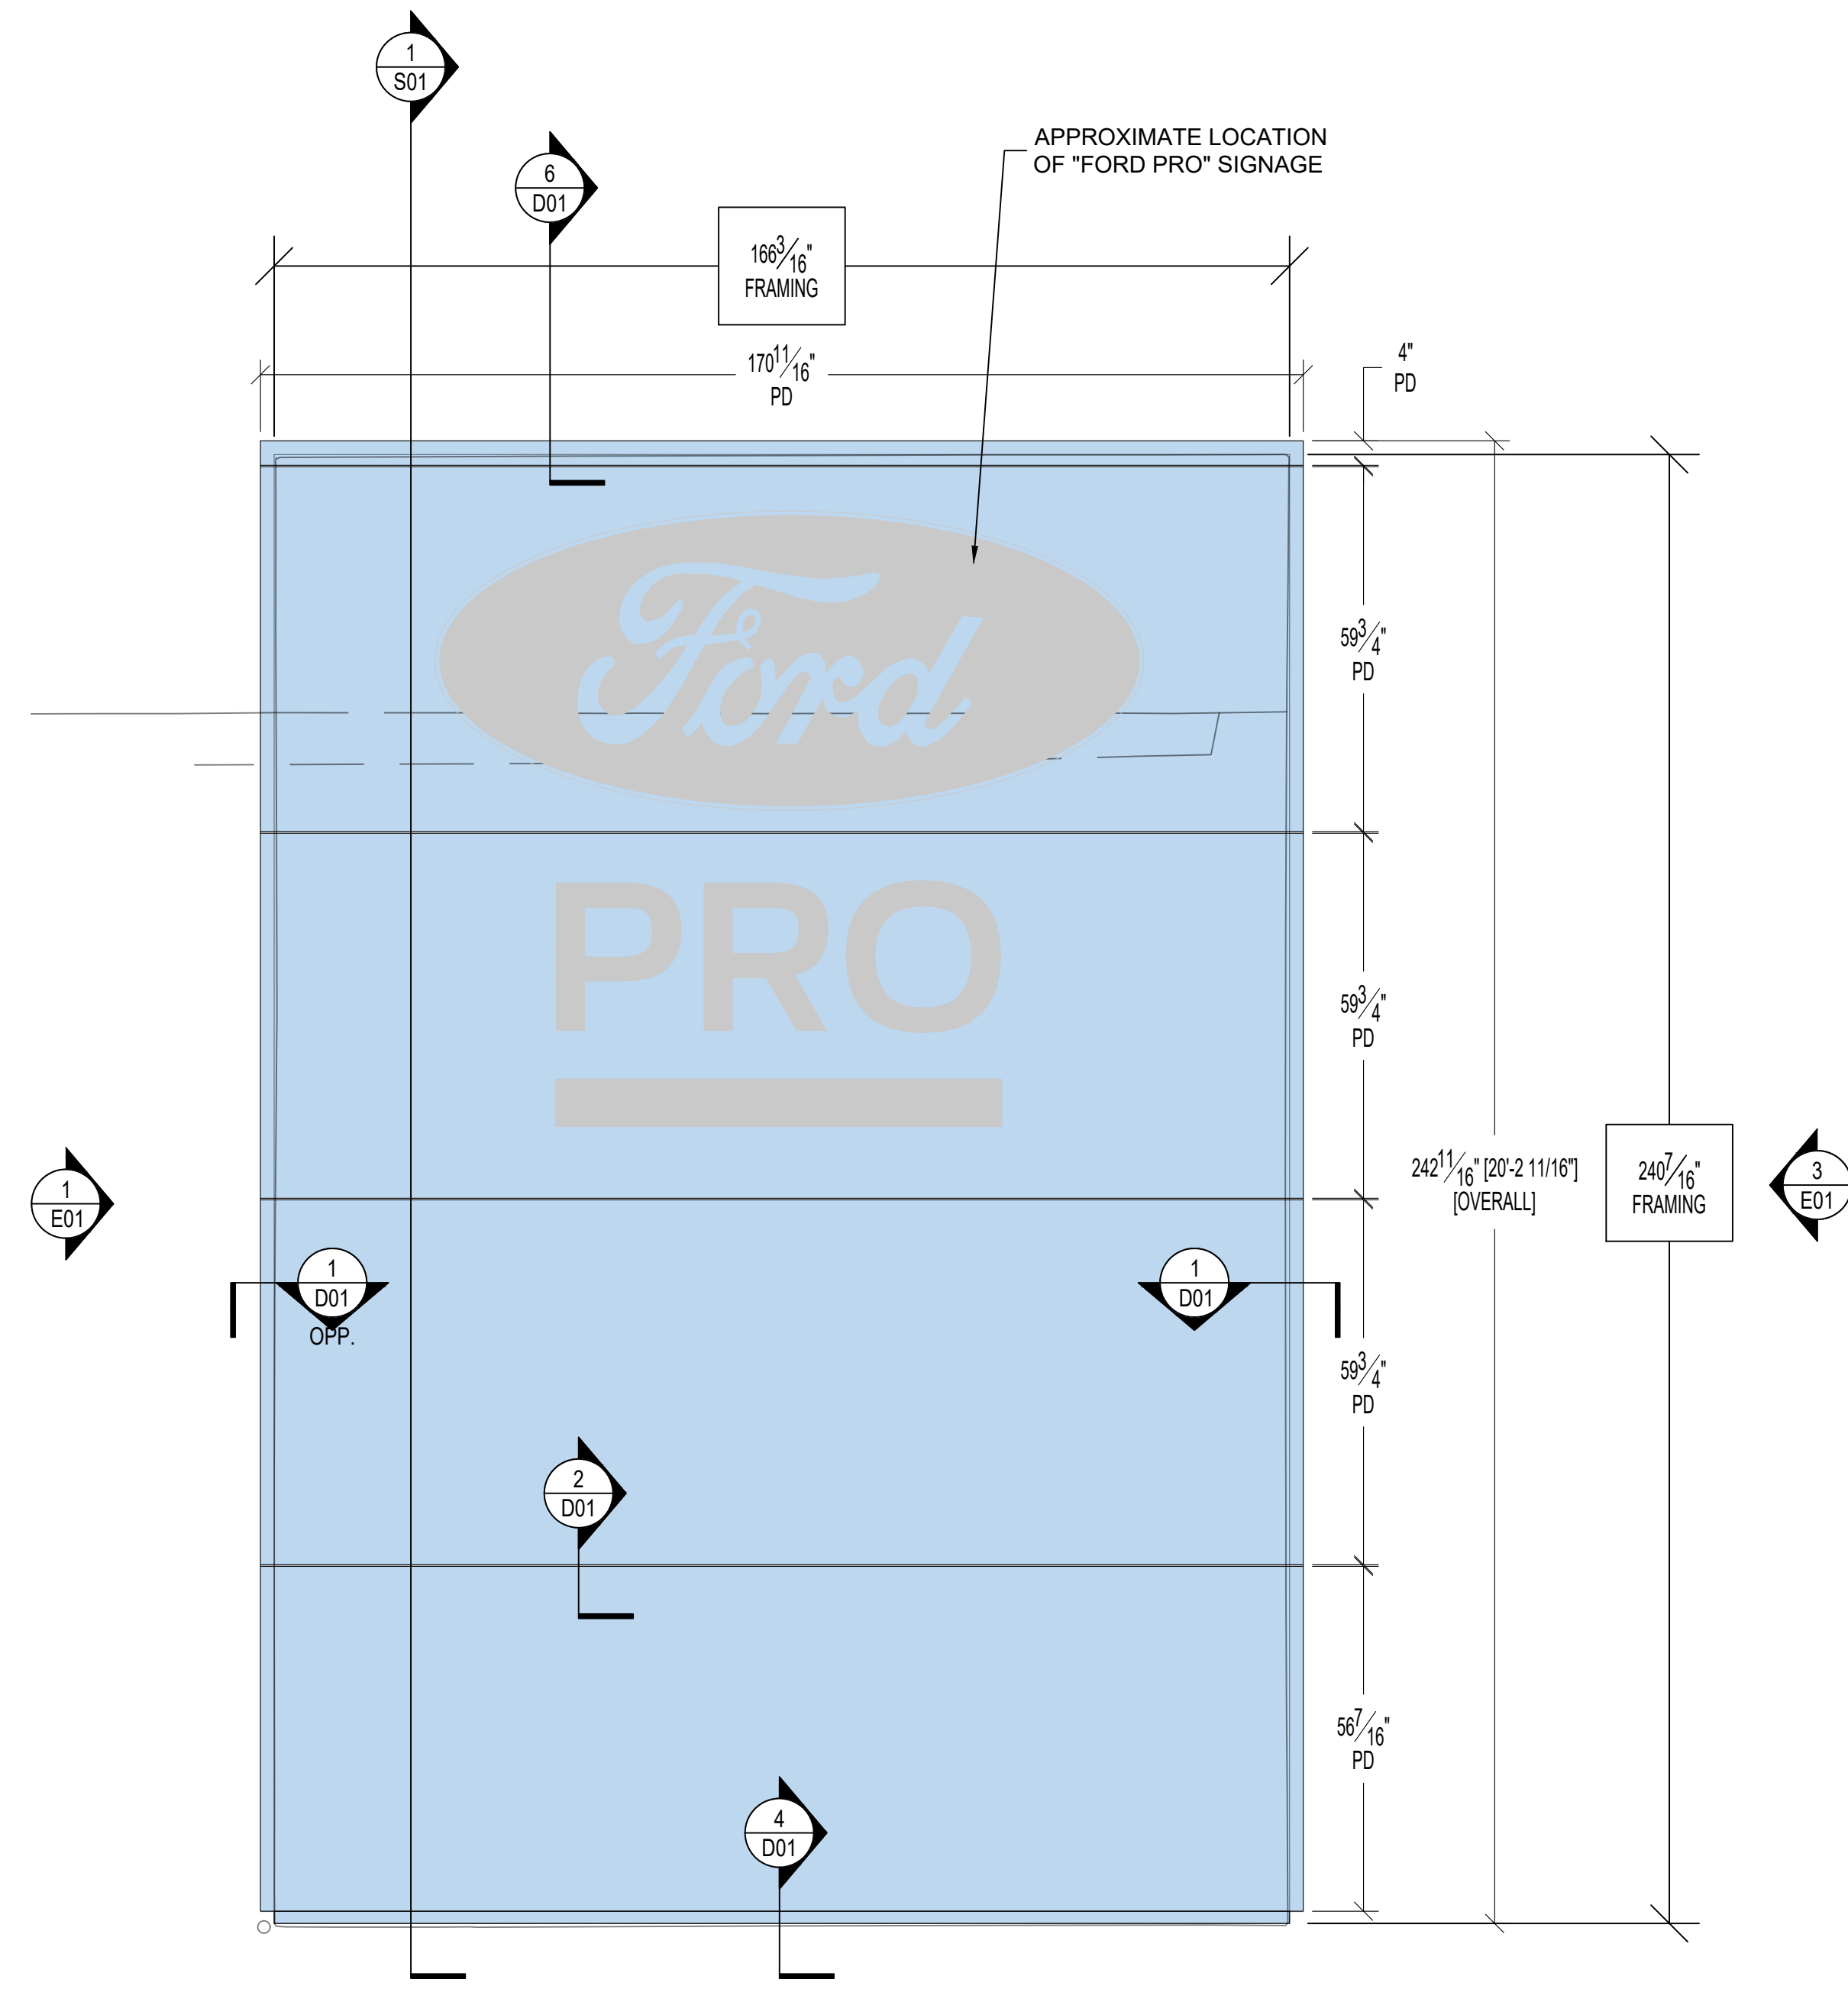


2 FORD PRO FRONT ELEVATION
E01 1/2"=1'-0"

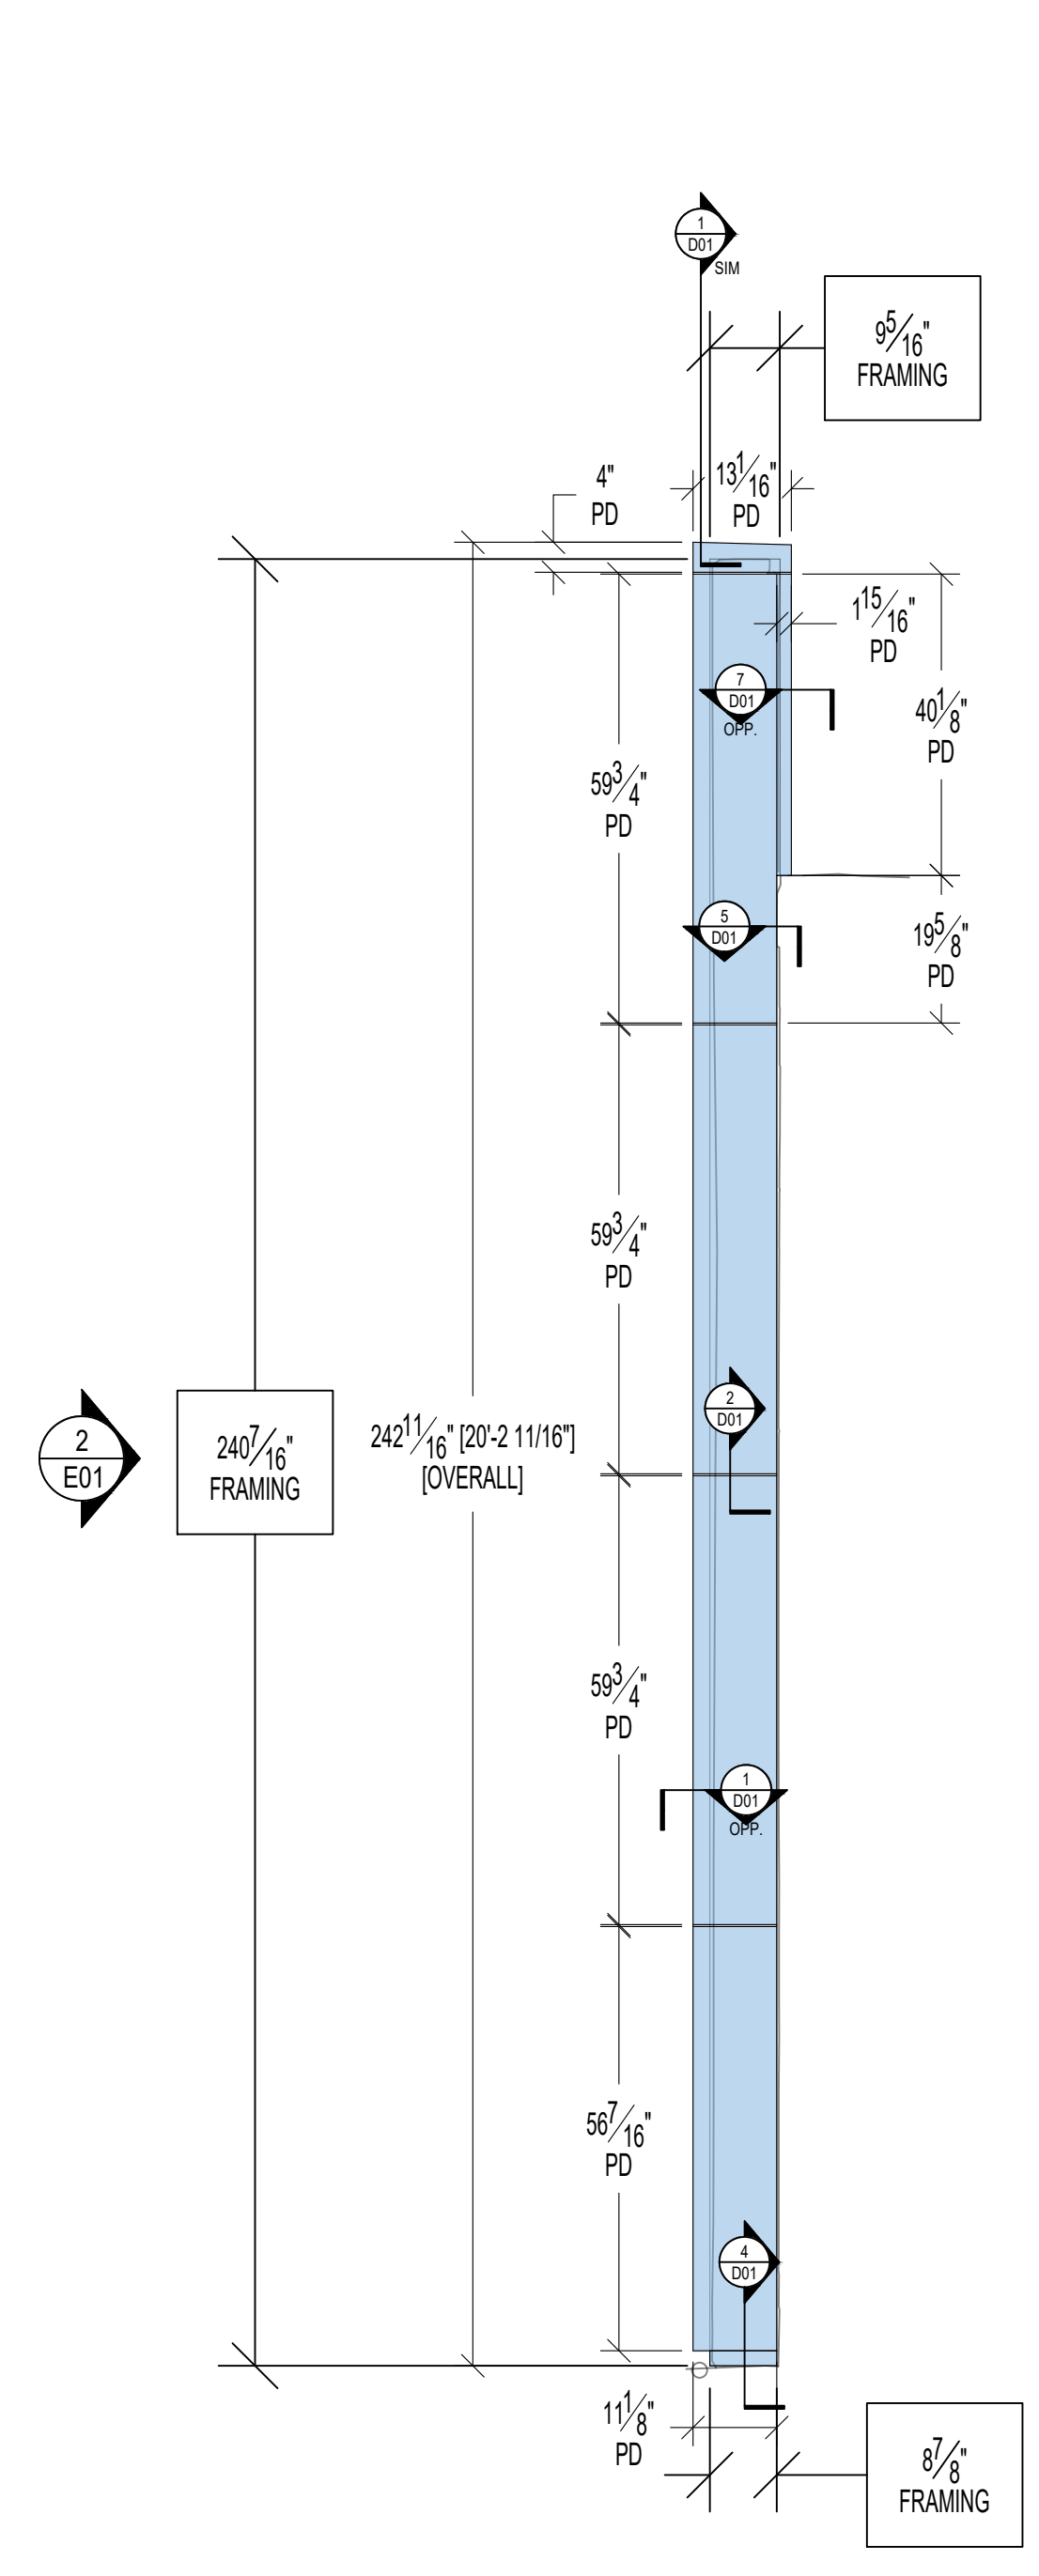

3 FORD PRO RIGHT ELEVATION
E01 1/2"=1'-0"

REV #	DATE	COMMENTS
△		
△		
△		
△		
△		


This document is the sole property of AGI, and all design, manufacturing, reproduction, use and sale rights regarding the same are expressly forbidden. It is submitted under a confidential relationship, for a special purpose, and the recipient, by accepting this document assumes custody and agrees that this document will not be copied or reproduced in whole or in part, nor its contents revealed in any manner or to any person except for the purpose for which it was rendered, nor any specific features peculiar to this design be incorporated in other projects.
Approved By: _____
Date Approved: _____

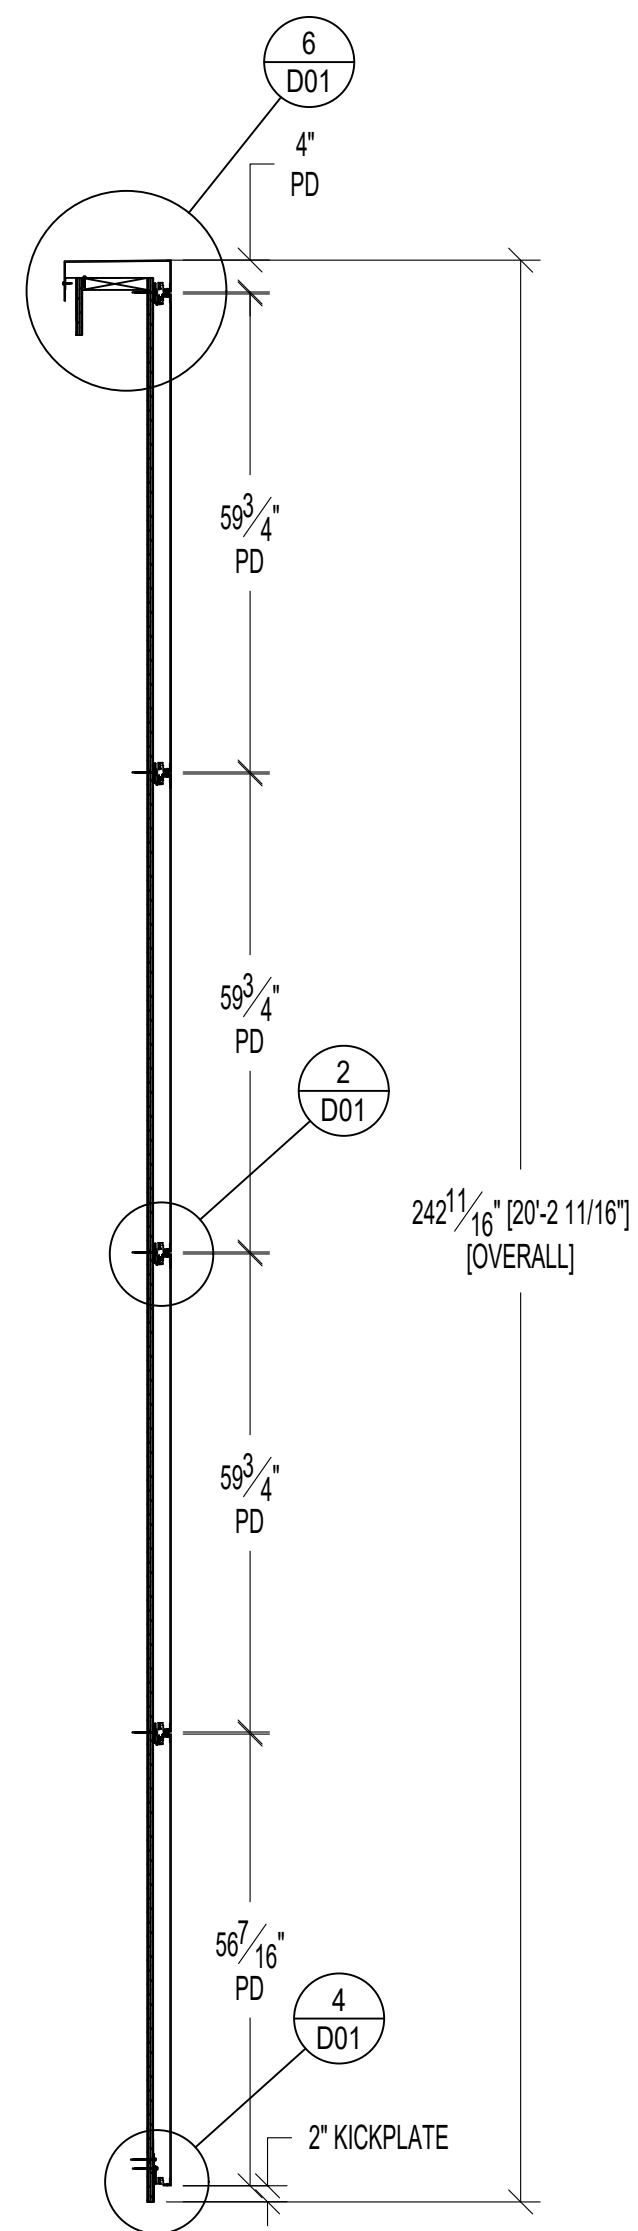


1 FORD PRO WALL SECTION
S01 1/2"=1'-0"

REV #	DATE	COMMENTS
△		
△		
△		
△		
△		


This document is the sole property of AGI, and all design, manufacturing, reproduction, use and sale rights regarding the same are expressly forbidden. It is submitted under a confidential relationship, for a special purpose, and the recipient, by accepting this document assumes custody and agrees that this document will not be copied or reproduced in whole or in part, nor its contents revealed in any manner or to any person except for the purpose for which it was tendered, nor any specific features peculiar to this design be incorporated in other projects.
Approved By: _____
Date Approved: _____

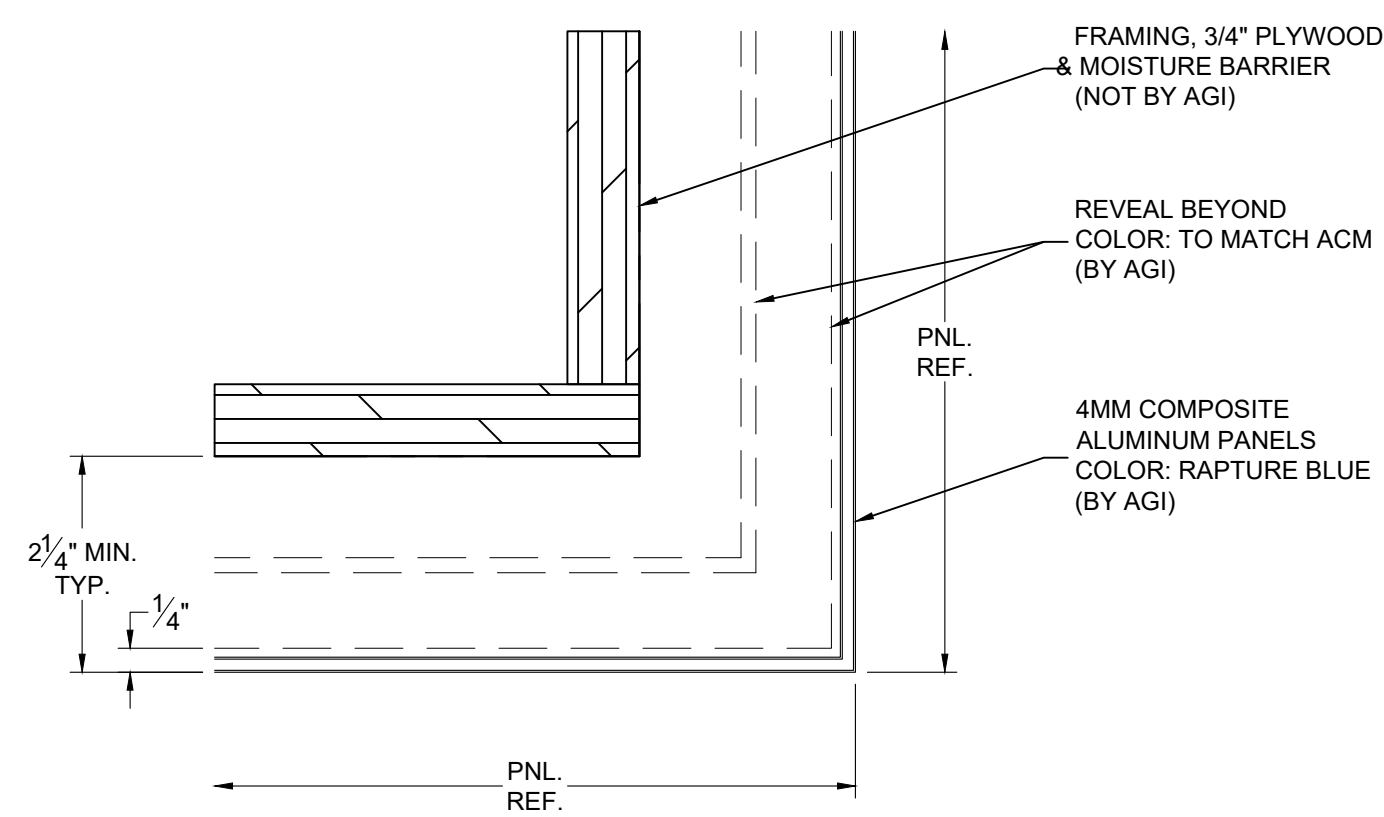


1 OUTSIDE CORNER DETAIL
D01 6"=1'-0"

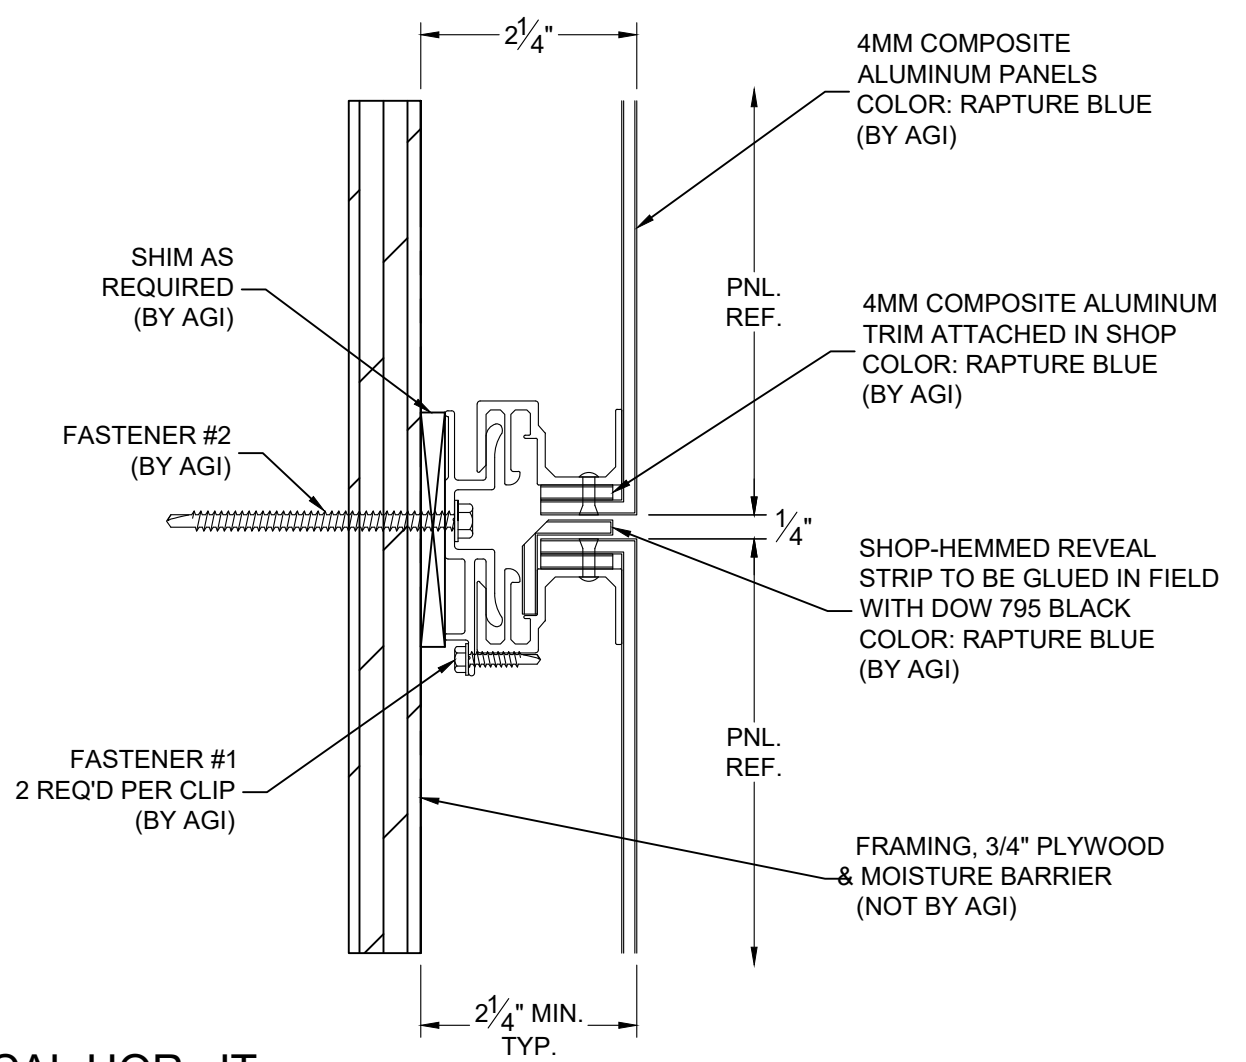


2 TYPICAL HOR. JT.
D01 6"=1'-0"

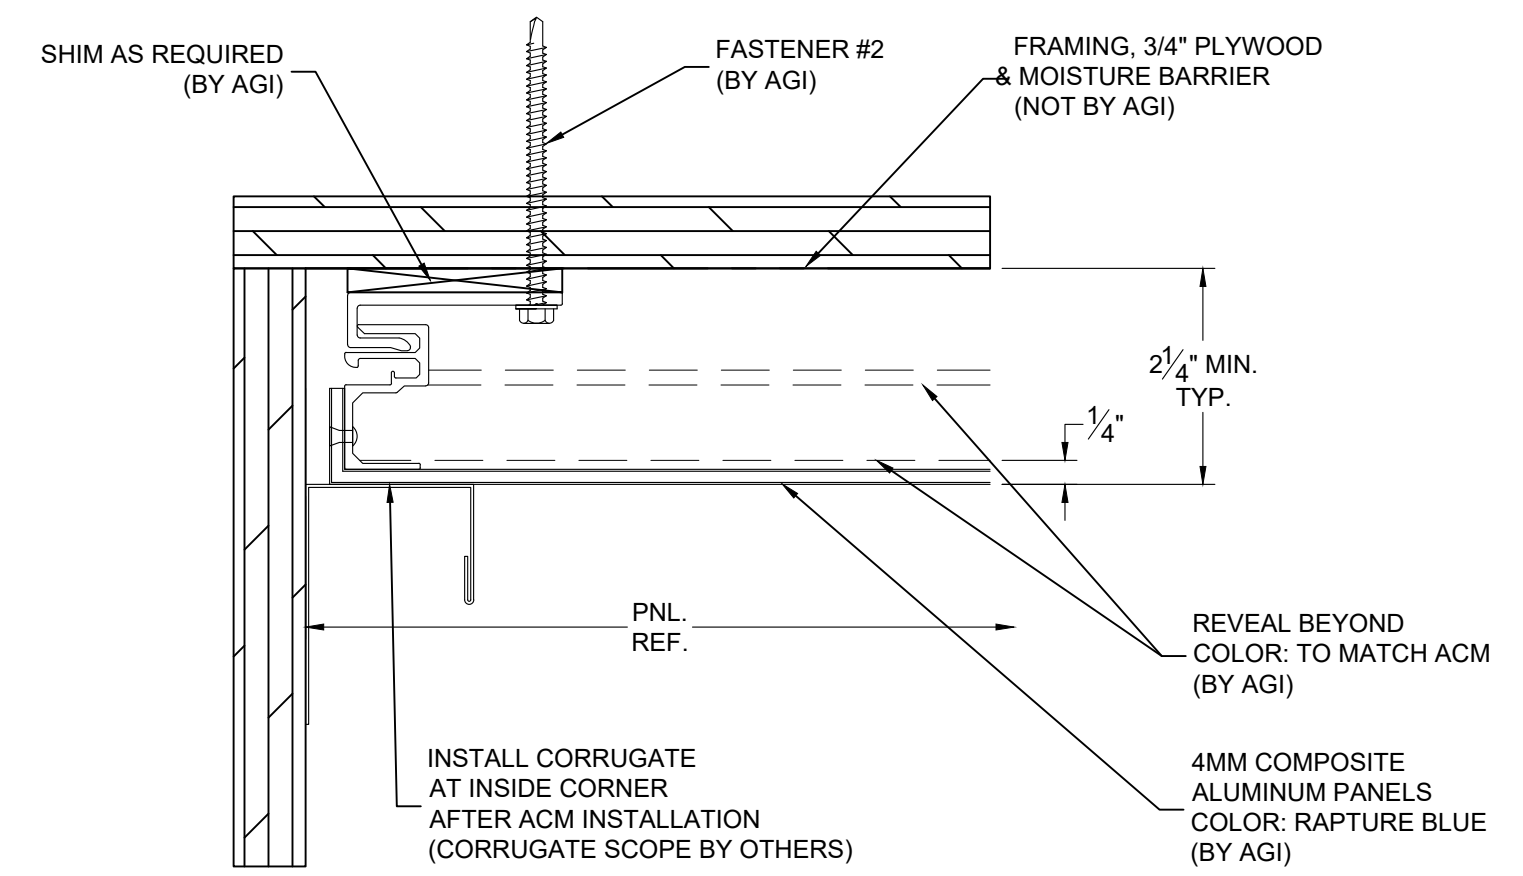


3 LEFT TERMINATION DETAIL
D01 6"=1'-0"

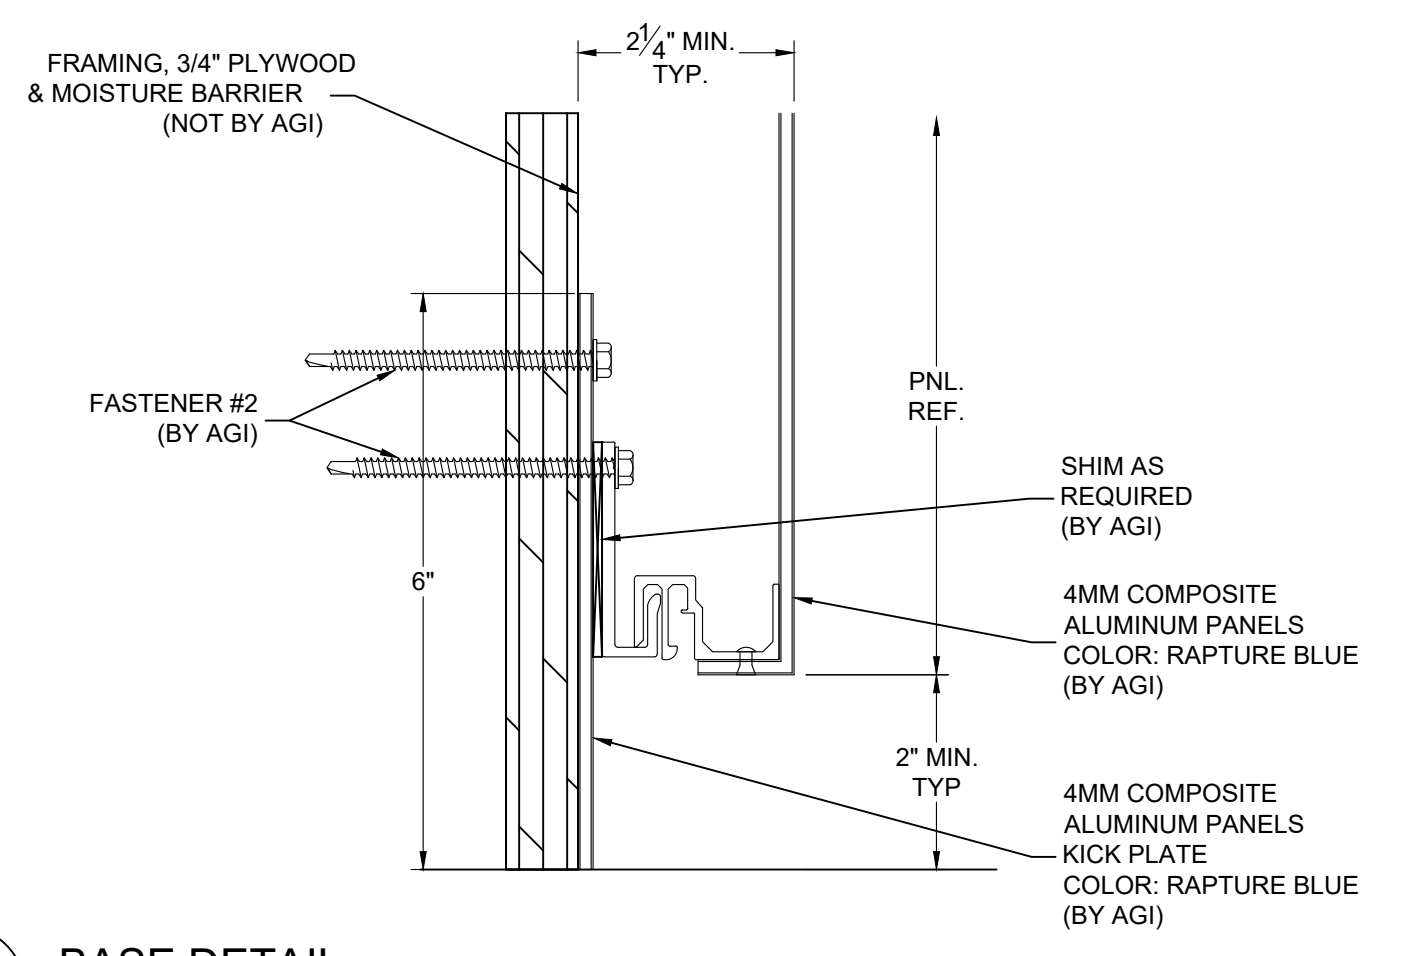


4 BASE DETAIL
D01 6"=1'-0"

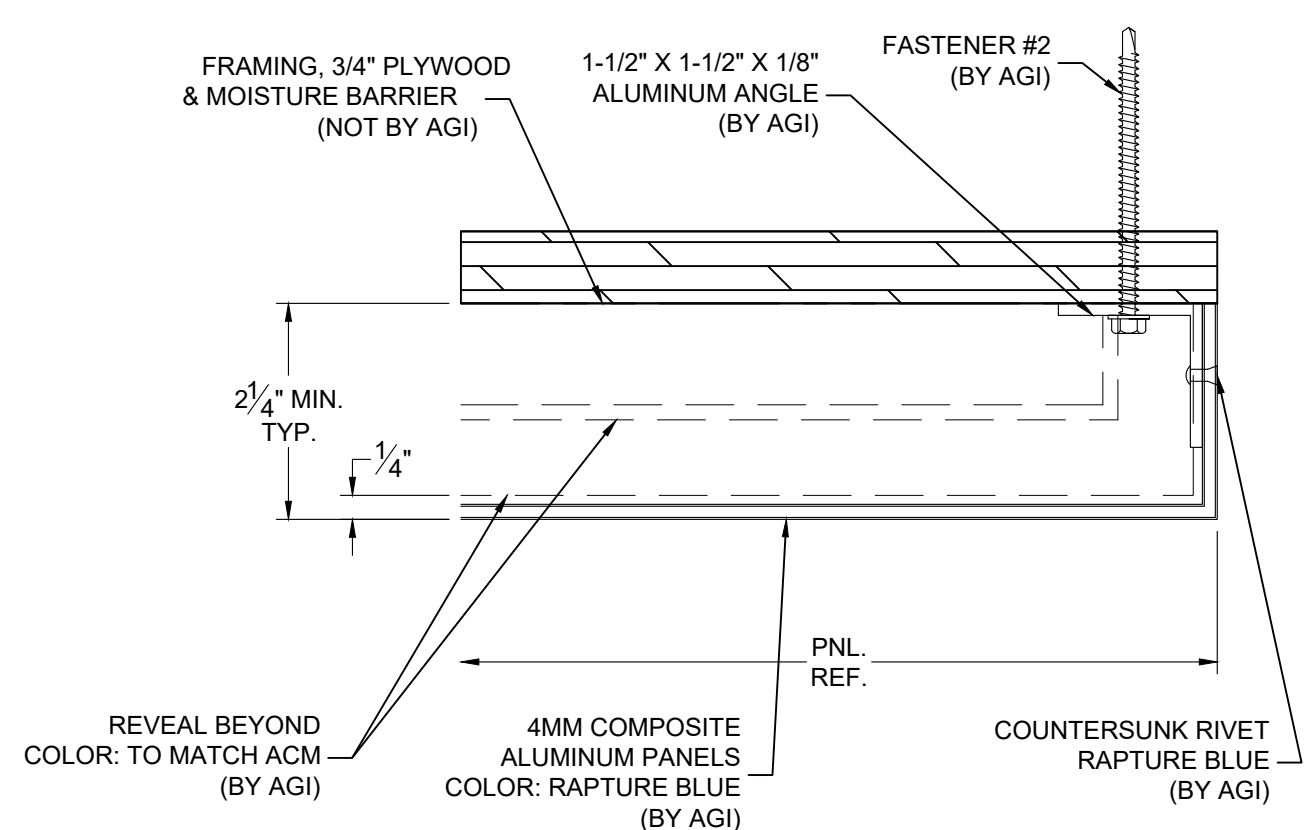

5 RIGHT TERMINATION DETAIL
D01 6"=1'-0"

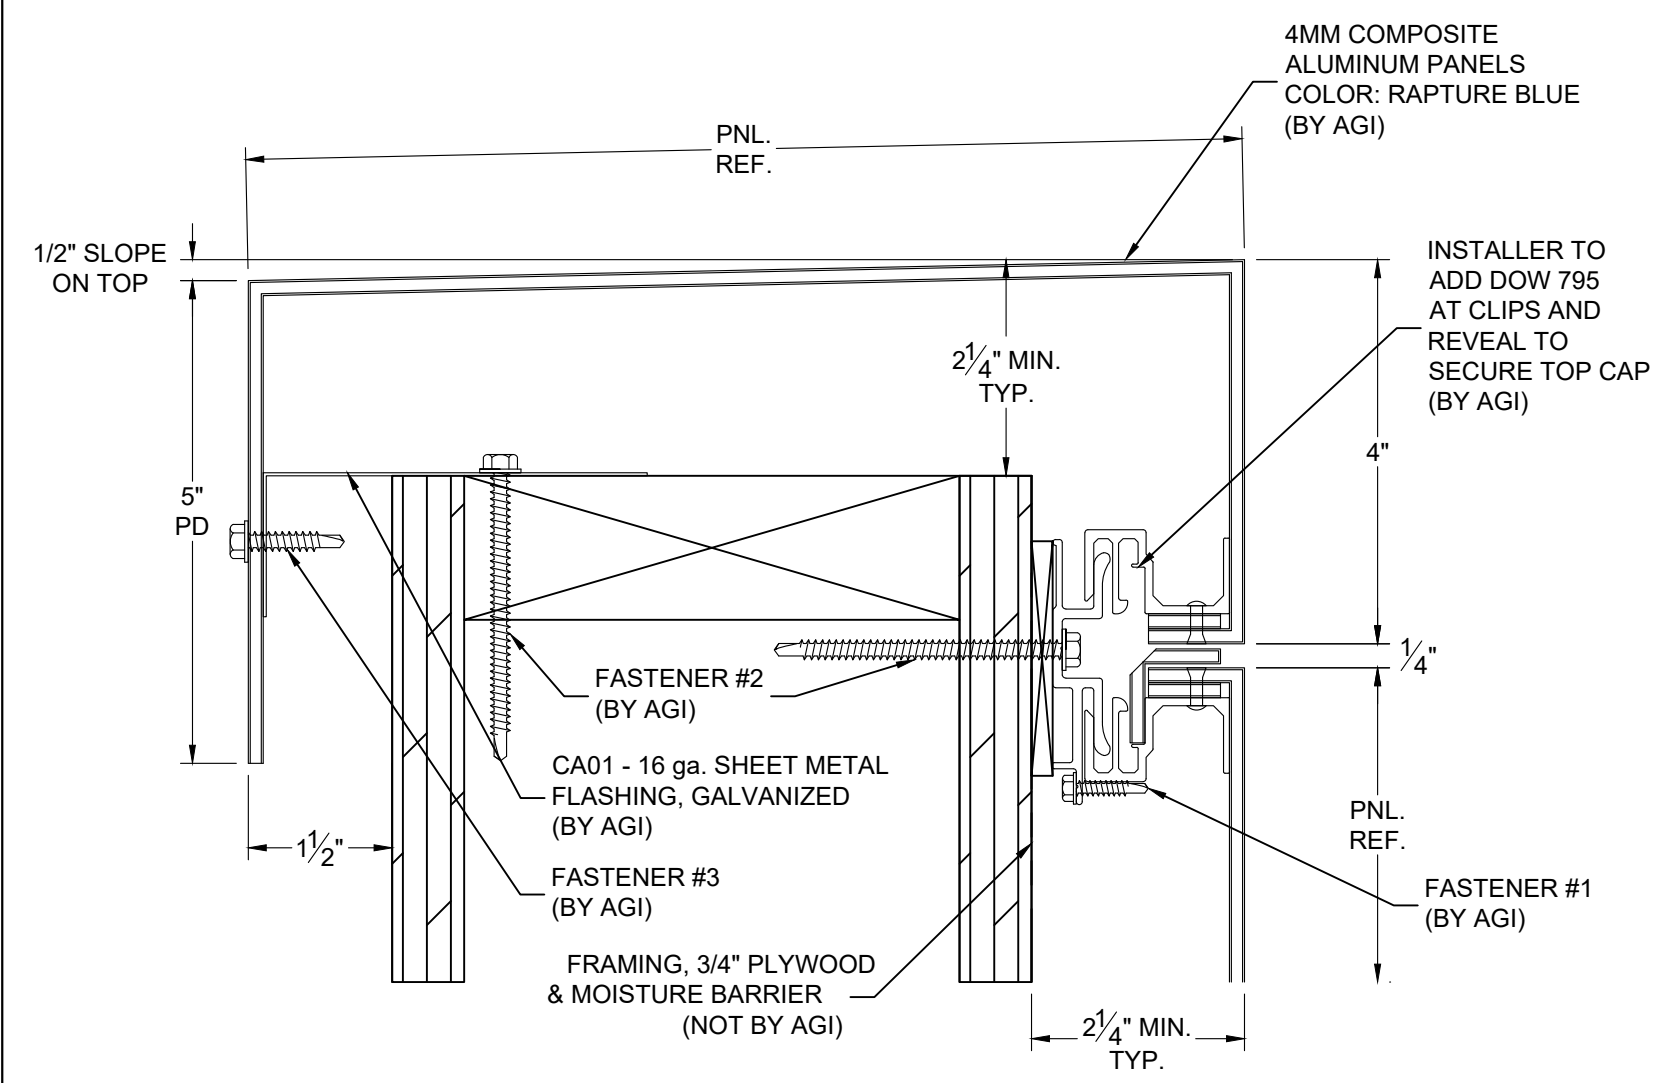

6 ACM COPING DETAIL
D01 6"=1'-0"

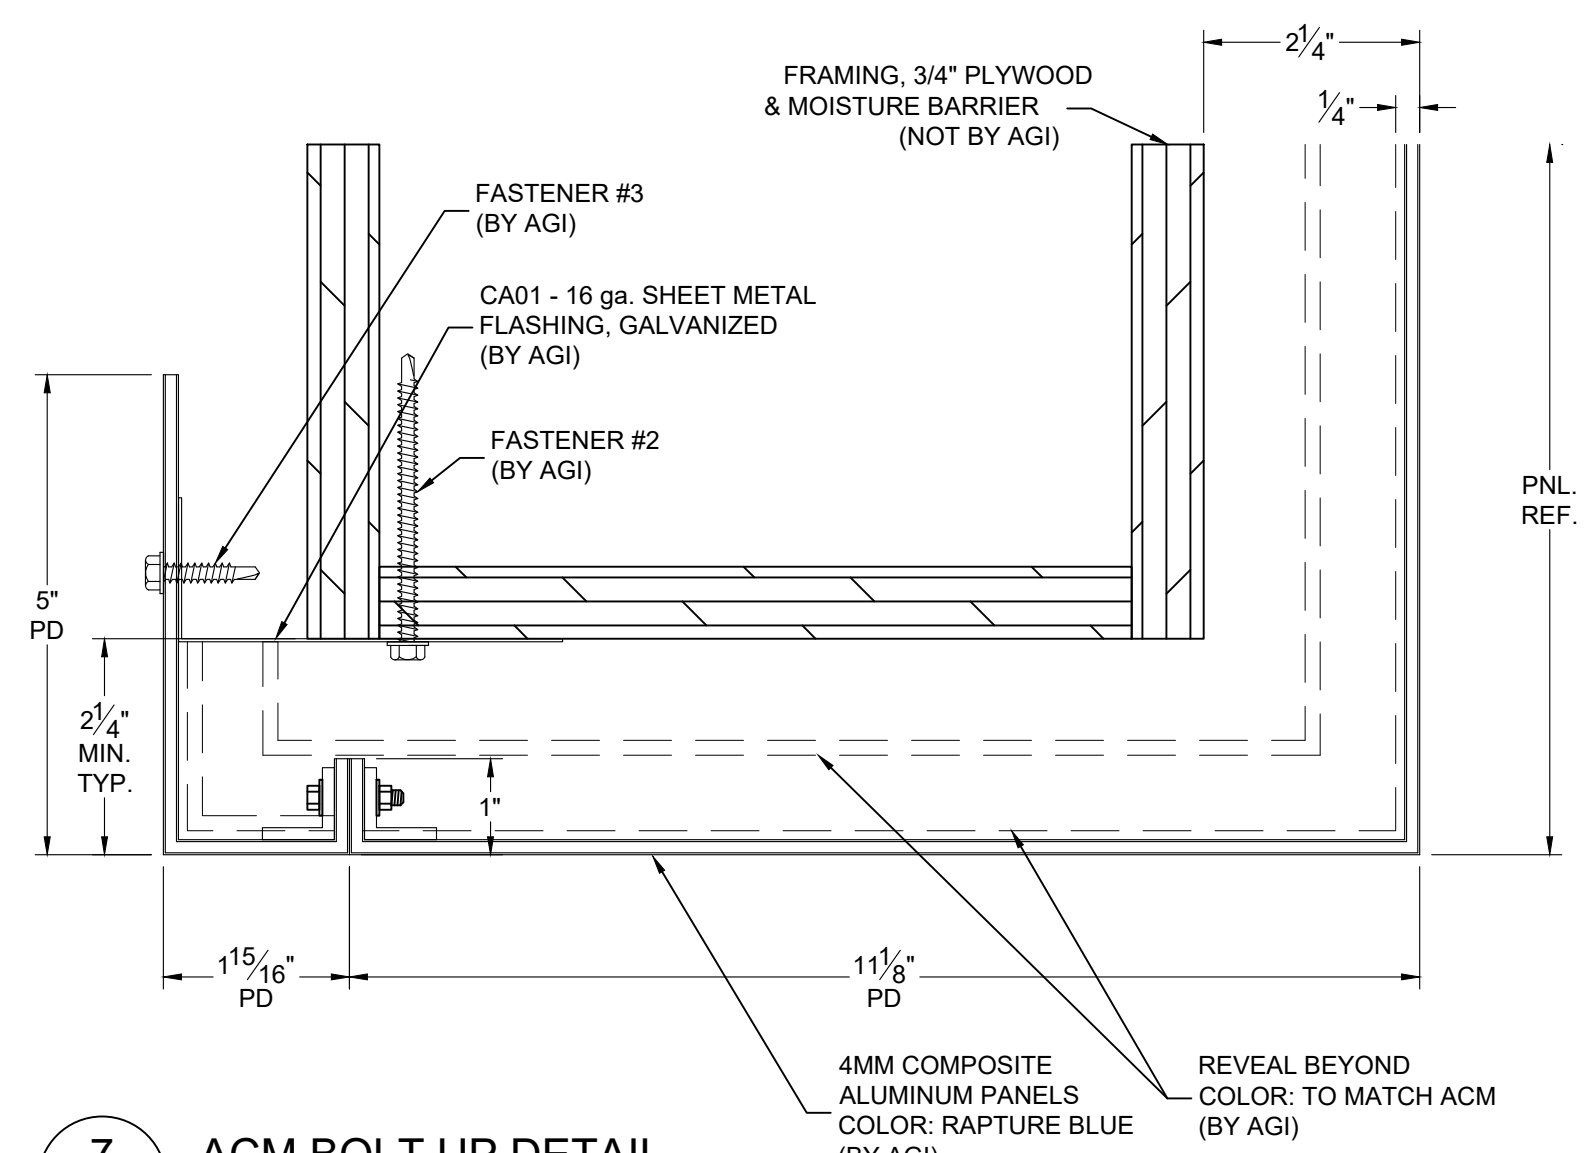

7 ACM BOLT UP DETAIL
D01 6"=1'-0"

REV #	DATE	COMMENTS
△		
△		
△		
△		
△		

This document is the sole property of AGI, and all design, manufacturing, reproduction, use and sale rights regarding the same are expressly forbidden. It is submitted under a confidential relationship, for a special purpose, and the recipient, by accepting this document assumes custody and agrees that this document will not be copied or reproduced in whole or in part, nor its contents revealed in any manner or to any person except for the purpose for which it was tendered, nor any specific features peculiar to this design be incorporated in other projects.

Approved By: _____
Date Approved: _____

PRO Pylon
"Elite Commercial Service"




Scale: 1/4"=1'


**THIS DRAWING IS AN ARTISTIC REPRESENTATION TO BE USED FOR PERMIT AND ESTIMATING PURPOSES ONLY.
TRUE DIMENSIONS MUST BE PROVIDED BY ENGINEERING PRIOR TO PRODUCTION.**

REVISIONS					
ZONE	REV.	ECR NUMBER	REV CHANGE	REV DATE	REV DRAFTER
	*	30323	INITIAL RELEASE	03/03/2023	BR


MATTHEWS 6 STAGE COATING:
 -TIEBOND PRIMER
 -WHITE MP 104926
 -BLACK MP 923
 -WHITE MP 104926
 -BRUSHED ALUMINUM MP SVOC 13655
 -SUPER STAIN CLEAR

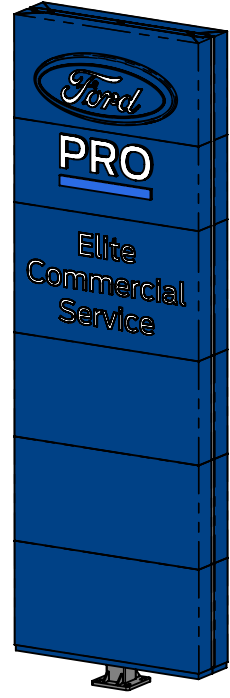

FRD-MNL20-115
 MONOLITH
 1929lbs

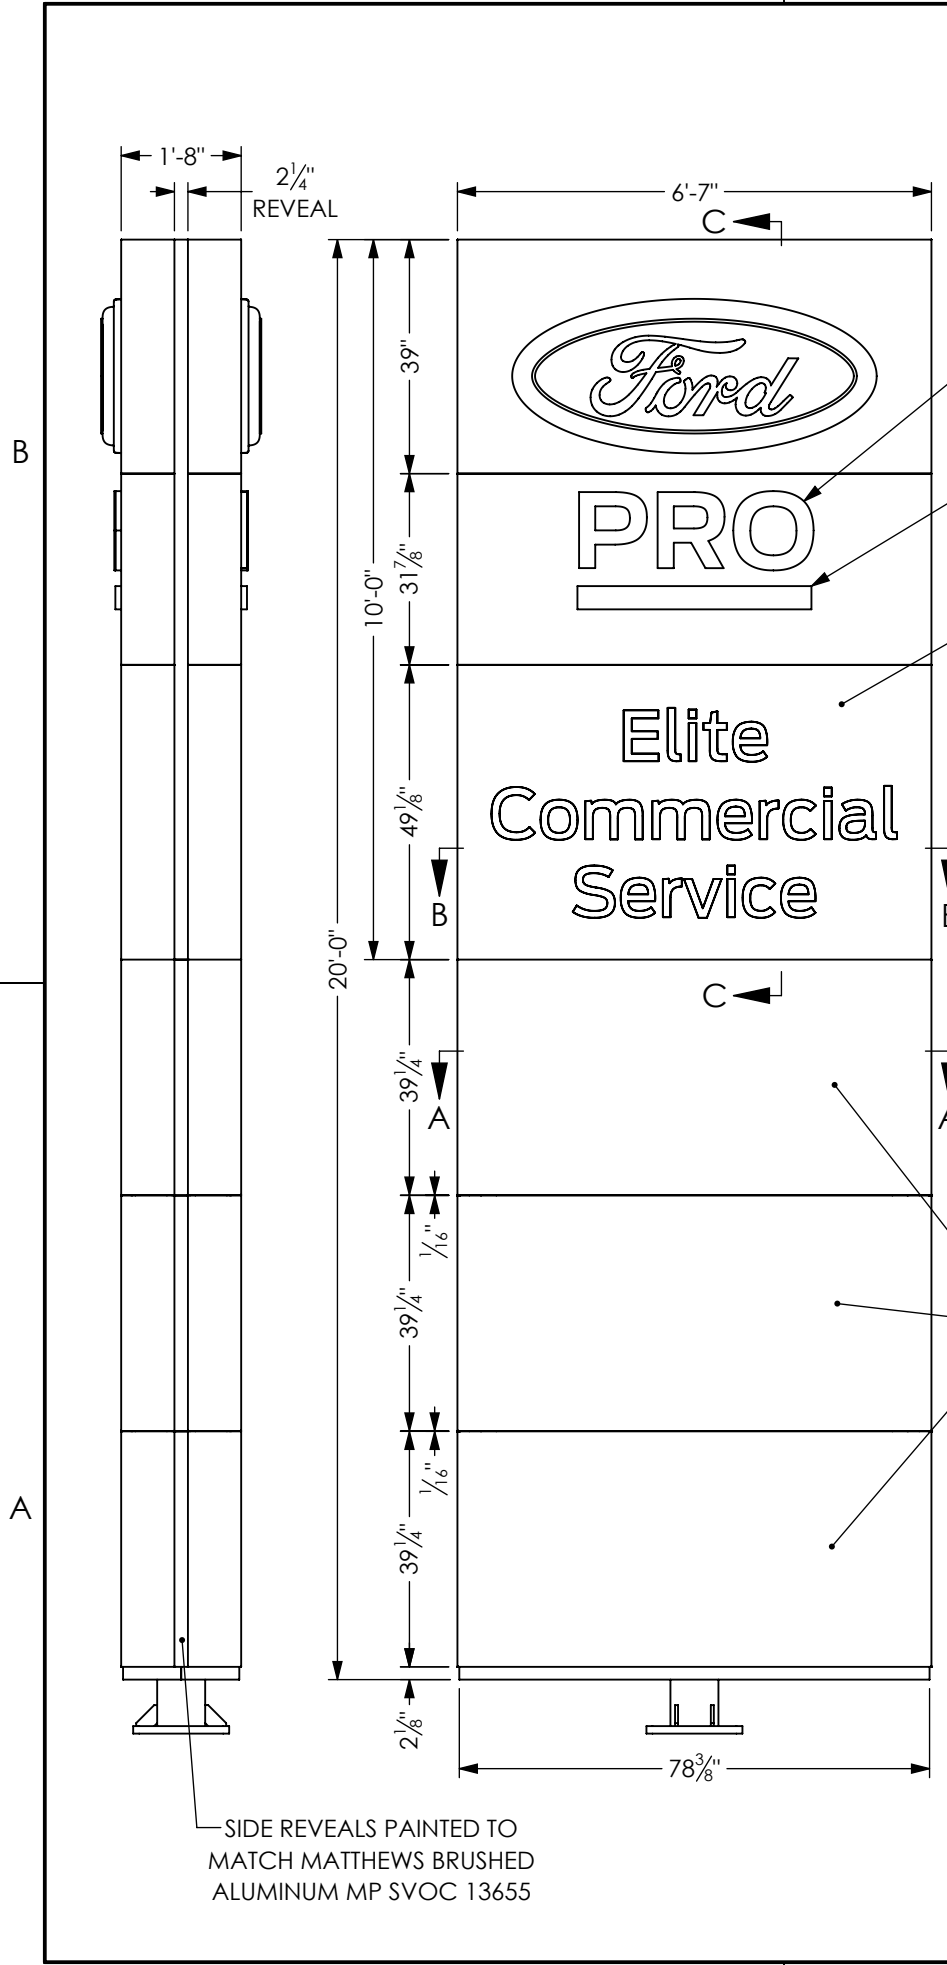


1.25" CLEAR PLASTIC W/ .177" #7328 WHITE ACRYLIC LAMINATED TO SURFACE AND SIDES TO HAVE MATTHEWS 6 STAGE COATING LISTED ABOVE.
 1.25" CLEAR PLASTIC W/ SURFACE APPLIED VINYL TO MATCH 'GRABBER BLUE' AND SIDES TO HAVE MATTHEWS 6 STAGE COATING LISTED ABOVE.
 4mm ALPOLIC 'RAPT BLUE' ACM HEAD ASSEMBLY (HINGED AT TOP)

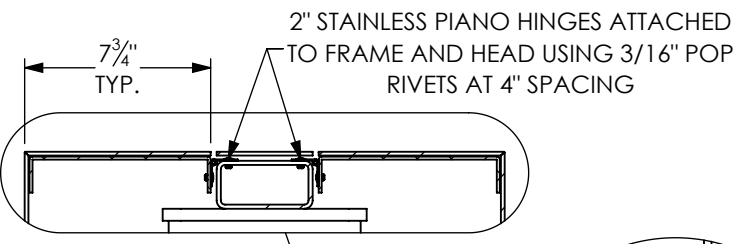


DETAIL F
 SCALE 1 : 8

4mm ALPOLIC 'RAPT BLUE' ACM PANELS

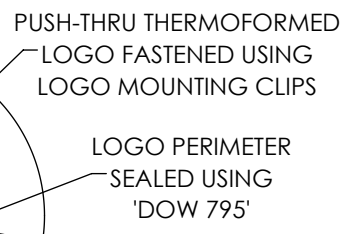


DETAIL G
 SCALE 1 : 4

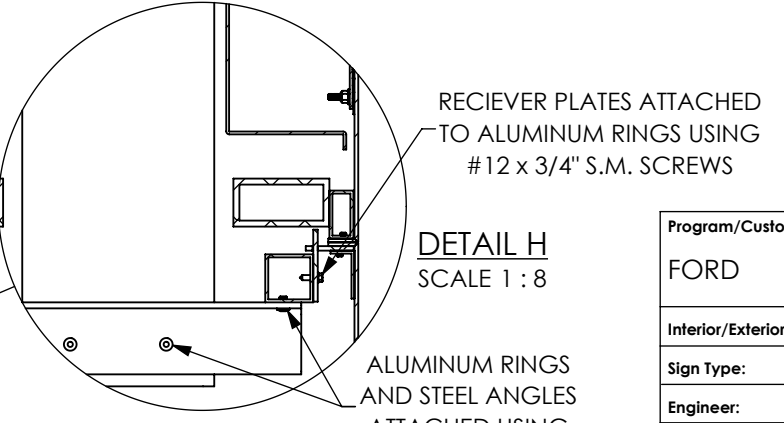


DETAIL H
 SCALE 1 : 8

SECTION C-C

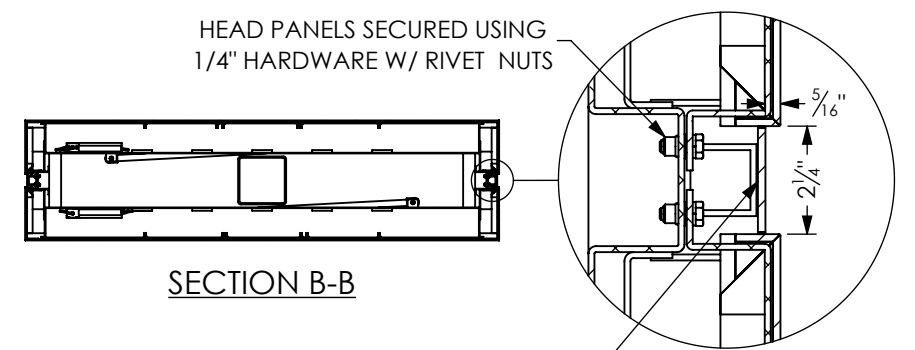

SECTION B-B

DETAIL E
 SCALE 1 : 4

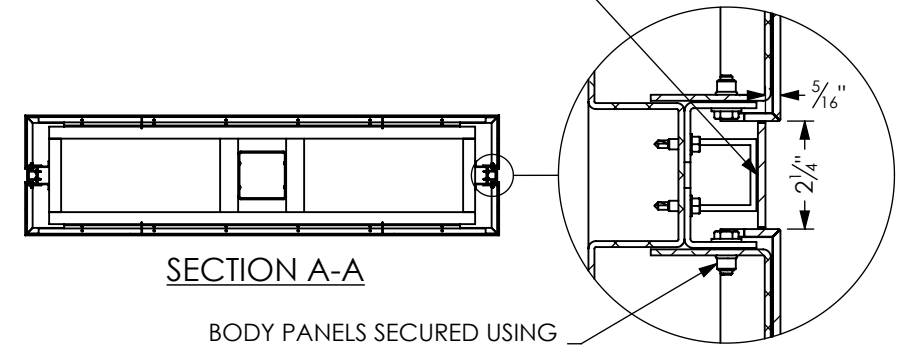

SECTION A-A

DETAIL D
 SCALE 1 : 4
 (SIDE REVEAL DETAIL)


BODY PANELS SECURED USING 1/4" HARDWARE W/ RIVET NUTS

Program/Customer:		FORD	
Interior/Exterior:	EXTERIOR		
Sign Type:	MONOLITH		
Engineer:	MATT SMITH		
Windspeed:	115 MPH IBC 2018		
illumination:	ILLUMINATED		
Voltage:	MULTI	SCALE: 1:32	


AGI

Description: MONOLITH
 Part Number: FRD-MNL20-115

REVISIONS					
ZONE	REV.	ECR NUMBER	REV CHANGE	REV DATE	REV DRAFTER
	*	30323	INITIAL RELEASE	03/03/2023	BR

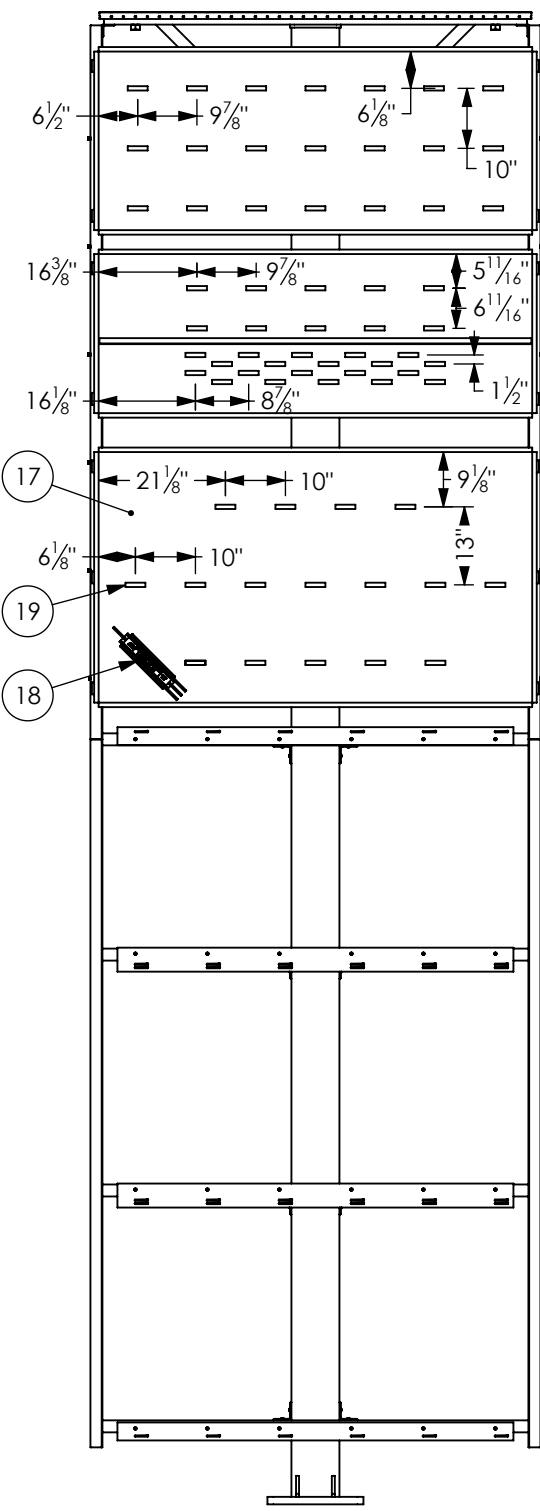

ELECTRICAL ELEVATION

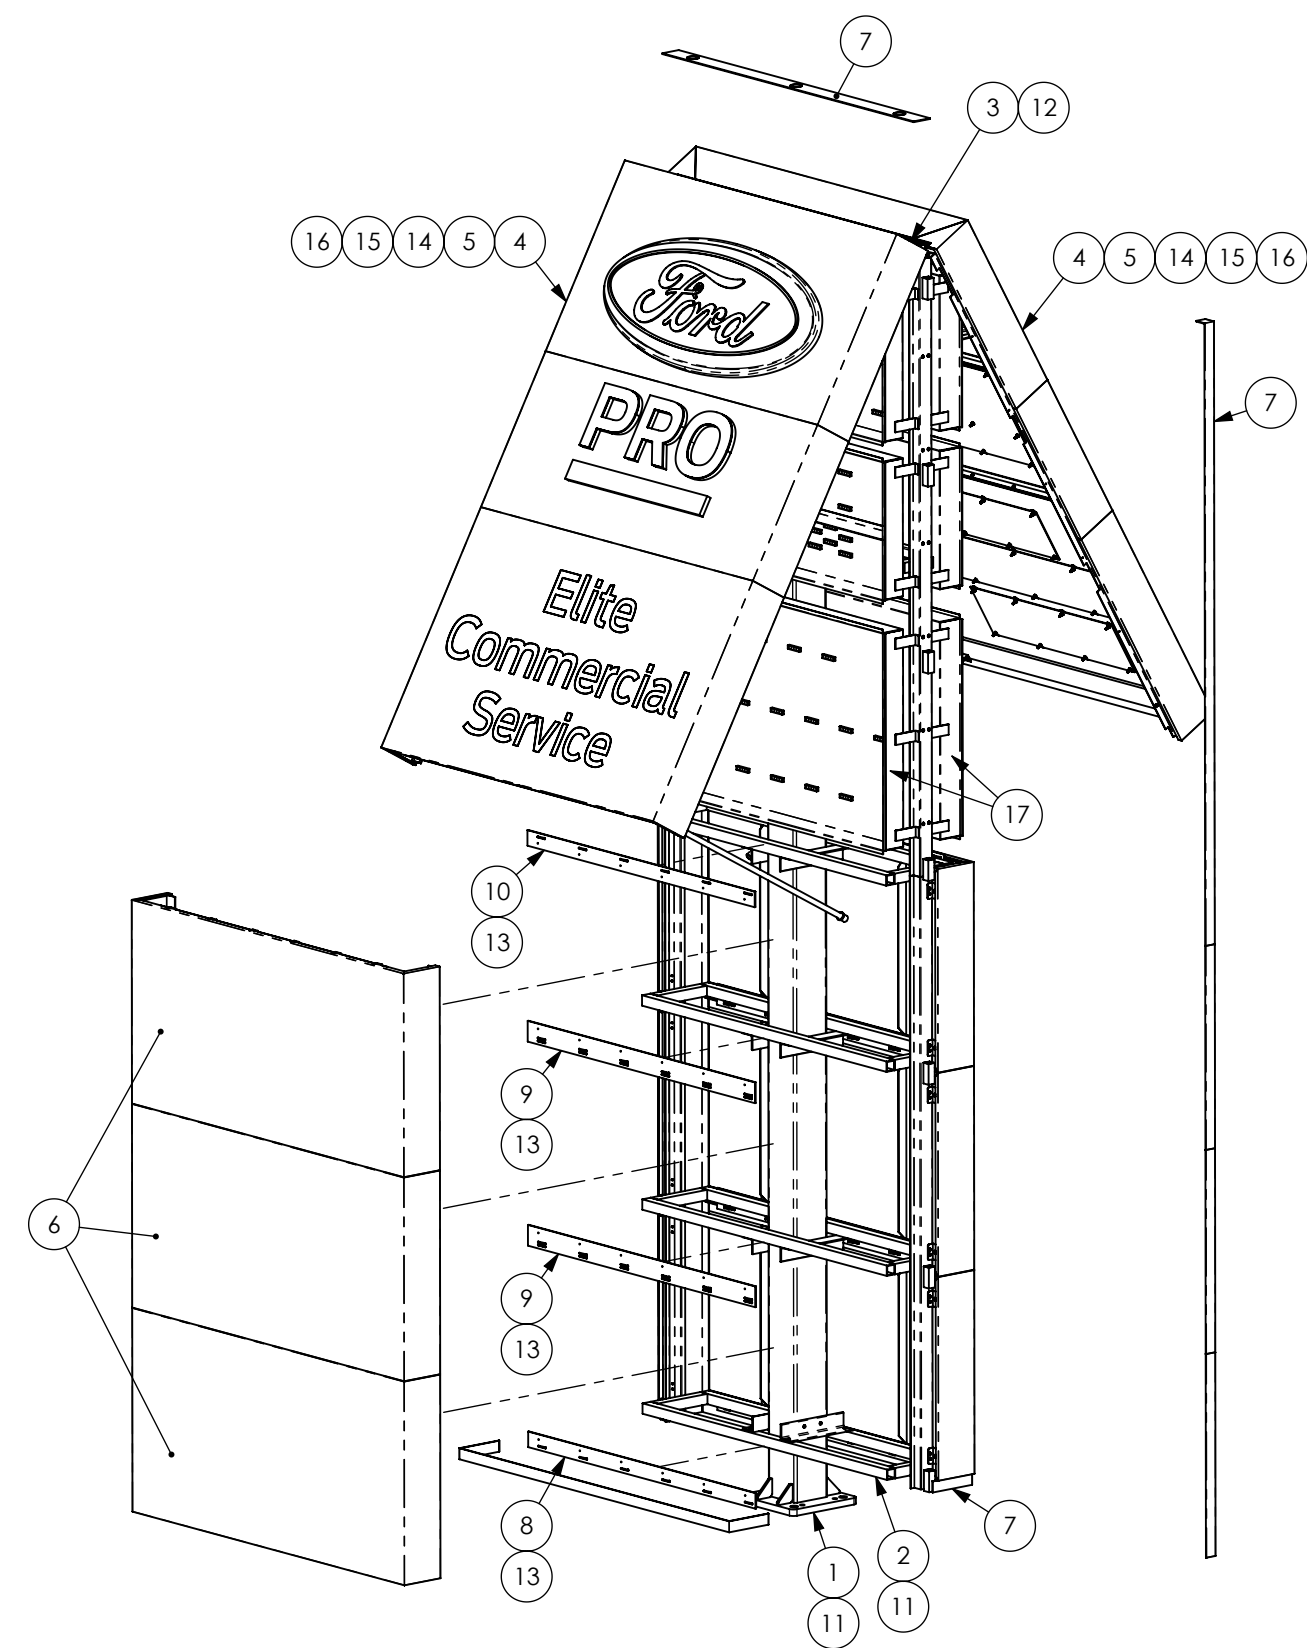

BOM TABLE: FRD-MNL20-115			
ITEM	PART NUMBER	DESCRIPTION	QTY.
1	FRD-MNL20-115-ST	STEEL FRAME	1
2	FRD-MNL20-AF	ALUMINUM SUB-FRAME	1
3	FRD-MNL20-HEAD-HINGE	2" S.S. PIANO HINGE	2
4	FRD-MNL20-HD	FRONT FACE HEAD ASSEMBLY	2
5	FRD-MNL20-PRA	PROP ROD ASSEMBLY	2
6	FRD-MNL20-PNL1	PANEL ASSEMBLY	6
7	FRD-MNL20-RC	MONOLITH REVEAL COVERS	1
8	AGI-SP12-RP-1A-6-66	SINGLE RECEIVING PLATE	2
9	AGI-SP12-RP-2A-6-66	DOUBLE RECEIVING PLATE	4
10	AGI-SP12-RP-1-6-66	SINGLE RECEIVING PLATE	2
11	MGLP-R8-E	1/4" HUCK RIVET-ST	32
12	MCM# 97447A050	3/16" ALUM. POP RIVET	72
13	MCM# 90054A294	#12X3/4" H.H.S.M. SCREW	48
14	MCM# 97467A725	1/4-20" RIVET NUT-SS	24
15	MCM# 92147A029	1/4" LOCK WASHER-S.S.	24
16	MCM# 93190A540	1/4-20X3/4 GD5 FT BOLT-SS	24
17	FRD-MNL20-PROTO-LB	LED LIGHT BOX	2
18	PS24-300W-3-GN	AGILIGHT POWER SUPPLY	2
19	LS-PRO4-24-HO-65K-300-A	AGILIGHT 6500K LED	134

Program/Customer:
FORD

Interior/Exterior:	EXTERIOR
Sign Type:	MONOLITH
Engineer:	MATT SMITH
Windspeed:	115 MPH IBC 2018
illumination:	ILLUMINATED
Voltage:	MULTI

Description:
MONOLITH

Part Number:
FRD-MNL20-115

SCALE: 1:32


NOTES:
 1. SHOP TO PROVIDE TOUCH UP PAINT FOR INSTALLER.
 2. INSTALLER TO MOUNT CANOPY/AWNING SLOPED AWAY FROM BUILDING AS SHOWN.

REVISIONS				
REV	DR NUMBER	REV CHANGE	DATE	DRAFTER
A	54568	INITIAL RELEASE	02.23.22	ELL

4 | 3 | 2 | 1

B


B

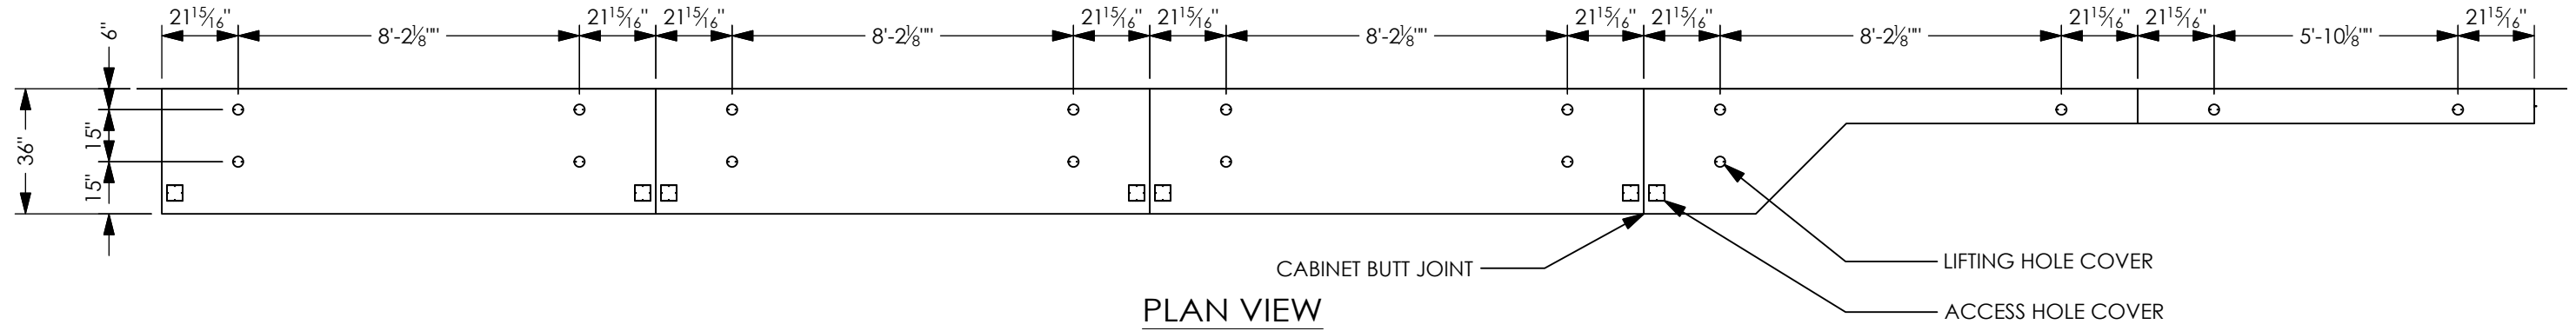

PLAN VIEW

A


A

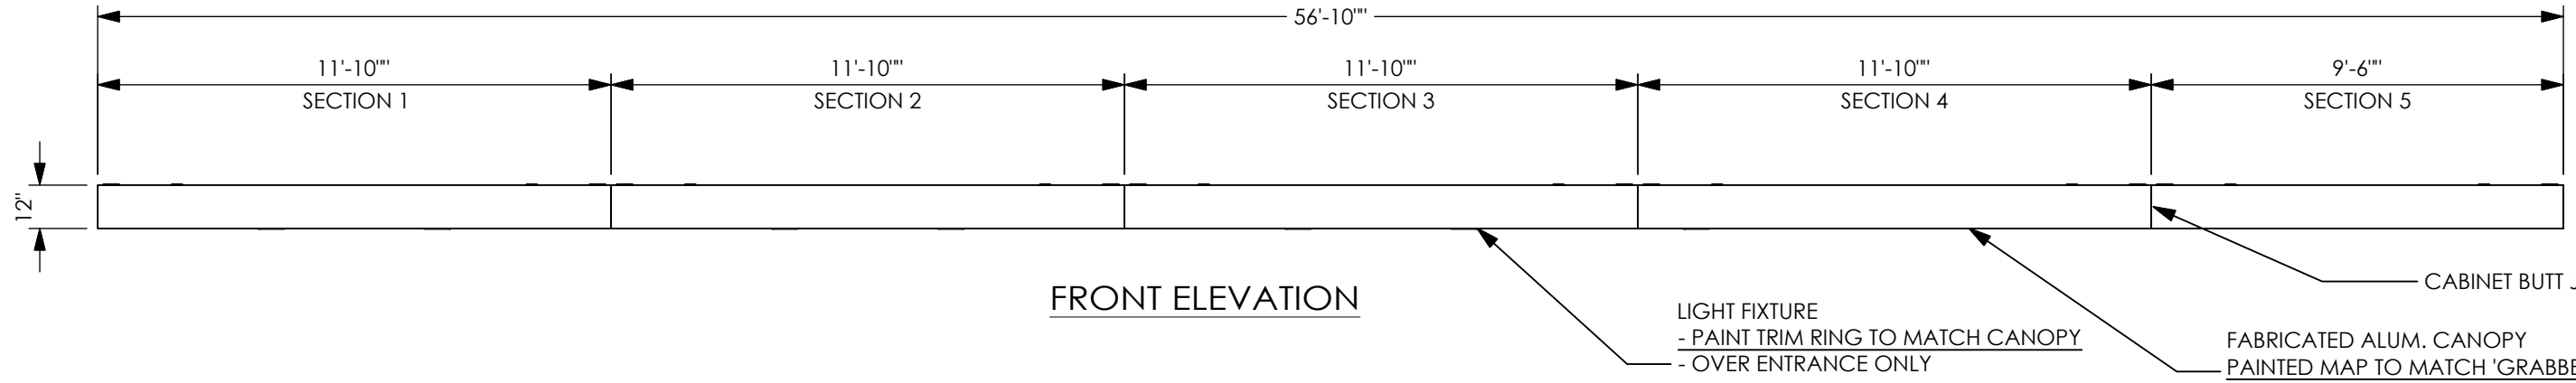

FRONT ELEVATION

A

A

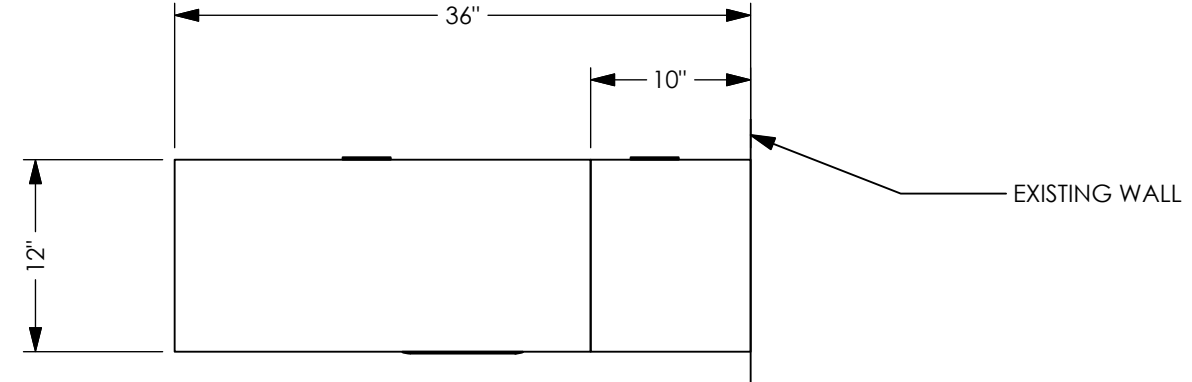

SIDE VIEW
 SCALE: 1" = 1'-0"

Program/Customer:		FORD	
Interior/Exterior:	EXTERIOR		
Sign Type:	WALL SIGN		
Engineer:	M. SMITH		
Windspeed:	115MPH/IBC 2012		
Illumination:	ILLUMINATION		
Voltage:	120V	SCALE: 1/4" = 1'-0"	



Description:
 GRABBER BAR
 Part Number:

FOR-C36


4

3

2


1

REVISIONS				
REV	DR NUMBER	REV CHANGE	DATE	DRAFTER
A	54568	INITIAL RELEASE	02.23.22	ELL

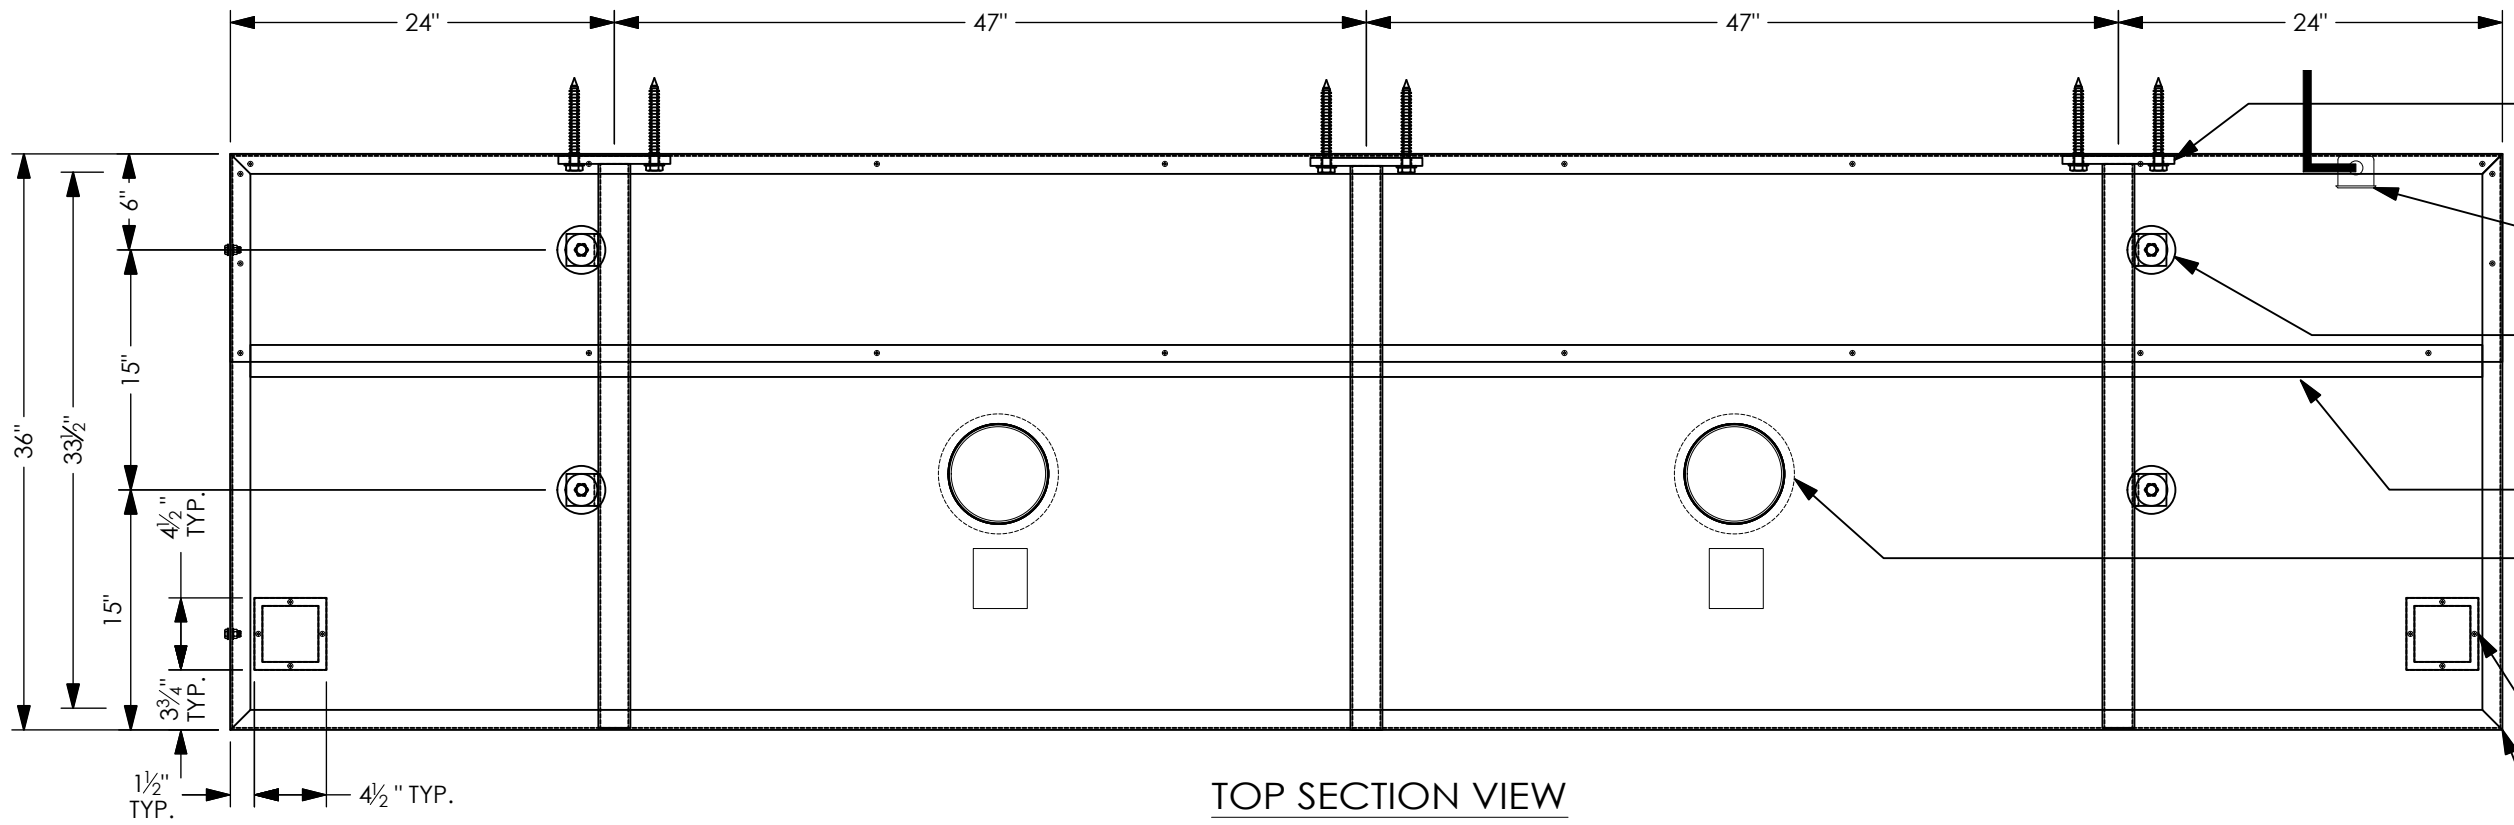


TOP SECTION VIEW

- 1/2" 6061-T6 ALUM. MOUNTING PLATE, TYP.
- 2 GANG ELECTRICAL MAKE UP BOX W/ ELECTRICAL CONDUIT FROM OWNER PROVIDED POWER SUPPLY -AT SECTION 3 ONLY
- ALUM COVER & ALUM DOUBLER FOR LIFTING HOLE
- .090" ALUM DOUBLER FOR ACCESS HOLE
- LOTUS LED LIGHT - 6" ROUND 17W SUPPER THIN LED -PART #LL6R-50K-BK
- ALUM COVER & ALUM DOUBLER FOR ACCESS HOLE
- AGI CHANNEL FRAME

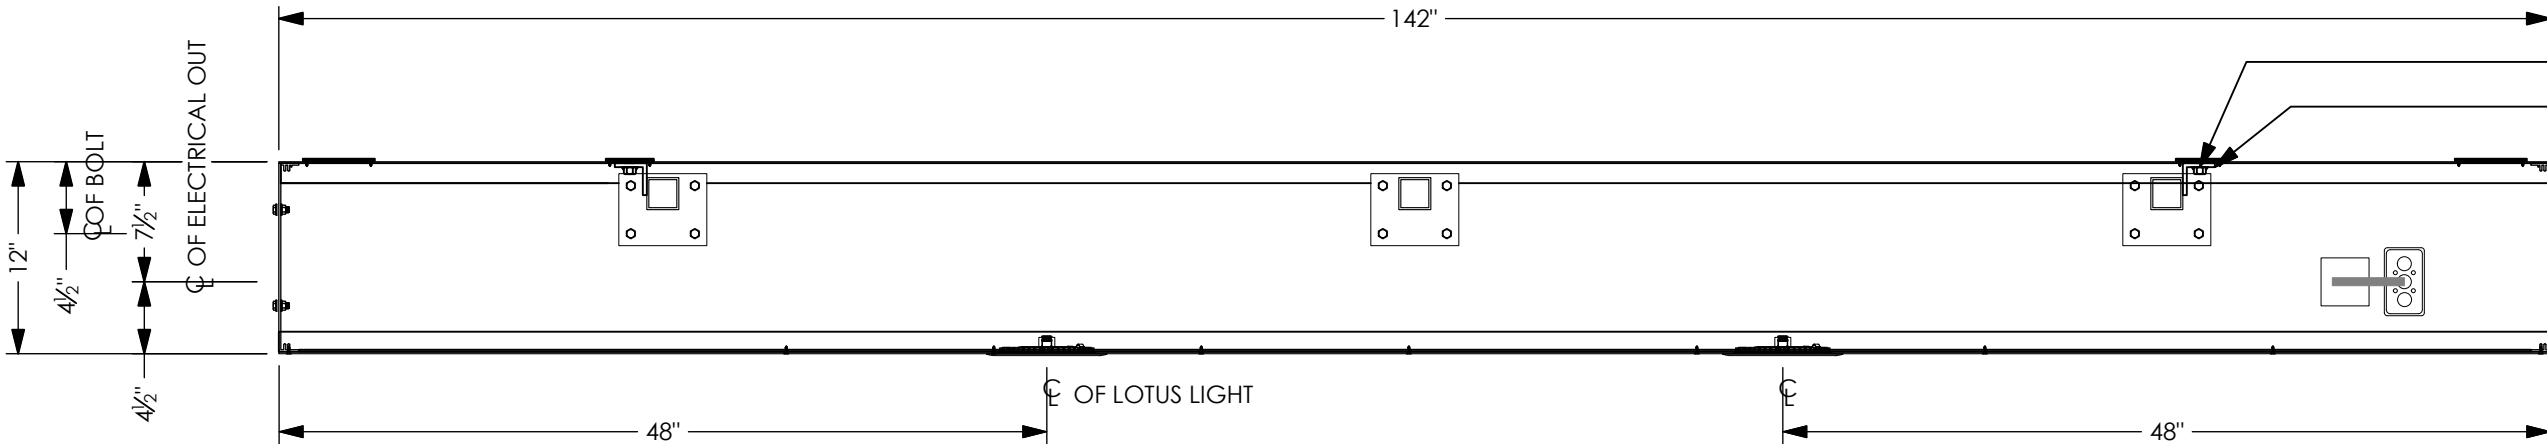


FRONT VIEW SECTIONS 1-3

- 1/2"Ø LIFTING NUT
- 2"X2"X1/4" X2" LONG ALUM ANGLE

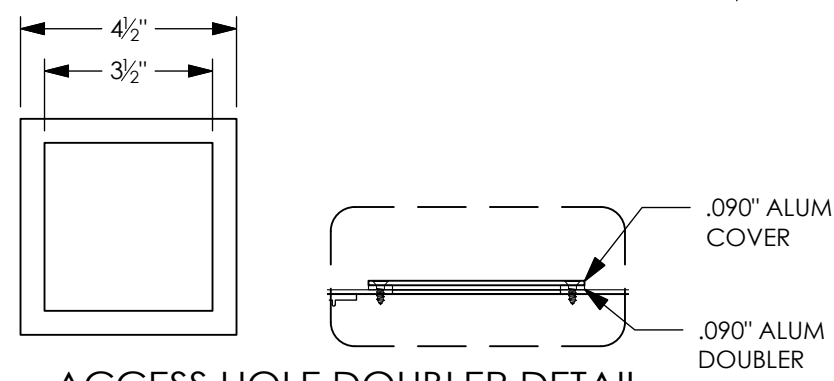

ACCESS HOLE DOUBLER DETAIL
SCALE: 1/4" = 1"

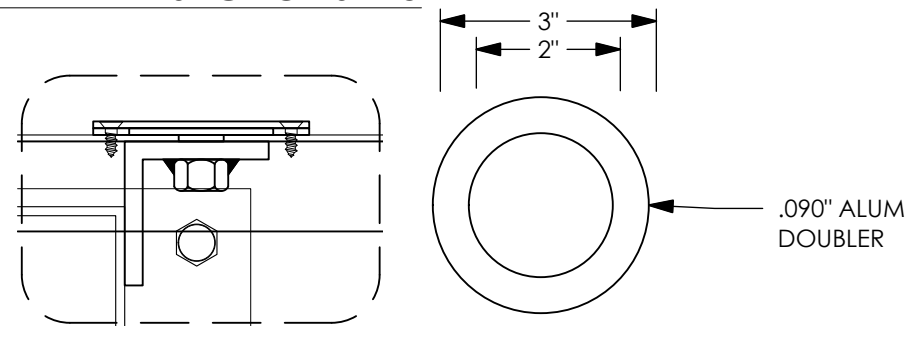

LIFTING HOLE DOUBLER DETAIL
SCALE: 3/8" = 1"

Program/Customer:		FORD
Interior/Exterior:	EXTERIOR	
Sign Type:	WALL SIGN	
Engineer:	M. SMITH	
Windspeed:	115MPH/IBC 2012	
Illumination:	ILLUMINATION	
Voltage:	120V	SCALE: 1/4" = 1'-0"



Description:
GRABBER BAR
Part Number:

FOR-C36


4

3


2

1

REVISIONS				
REV	DR NUMBER	REV CHANGE	DATE	DRAFTER
A	54568	INITIAL RELEASE	02.23.22	ELL

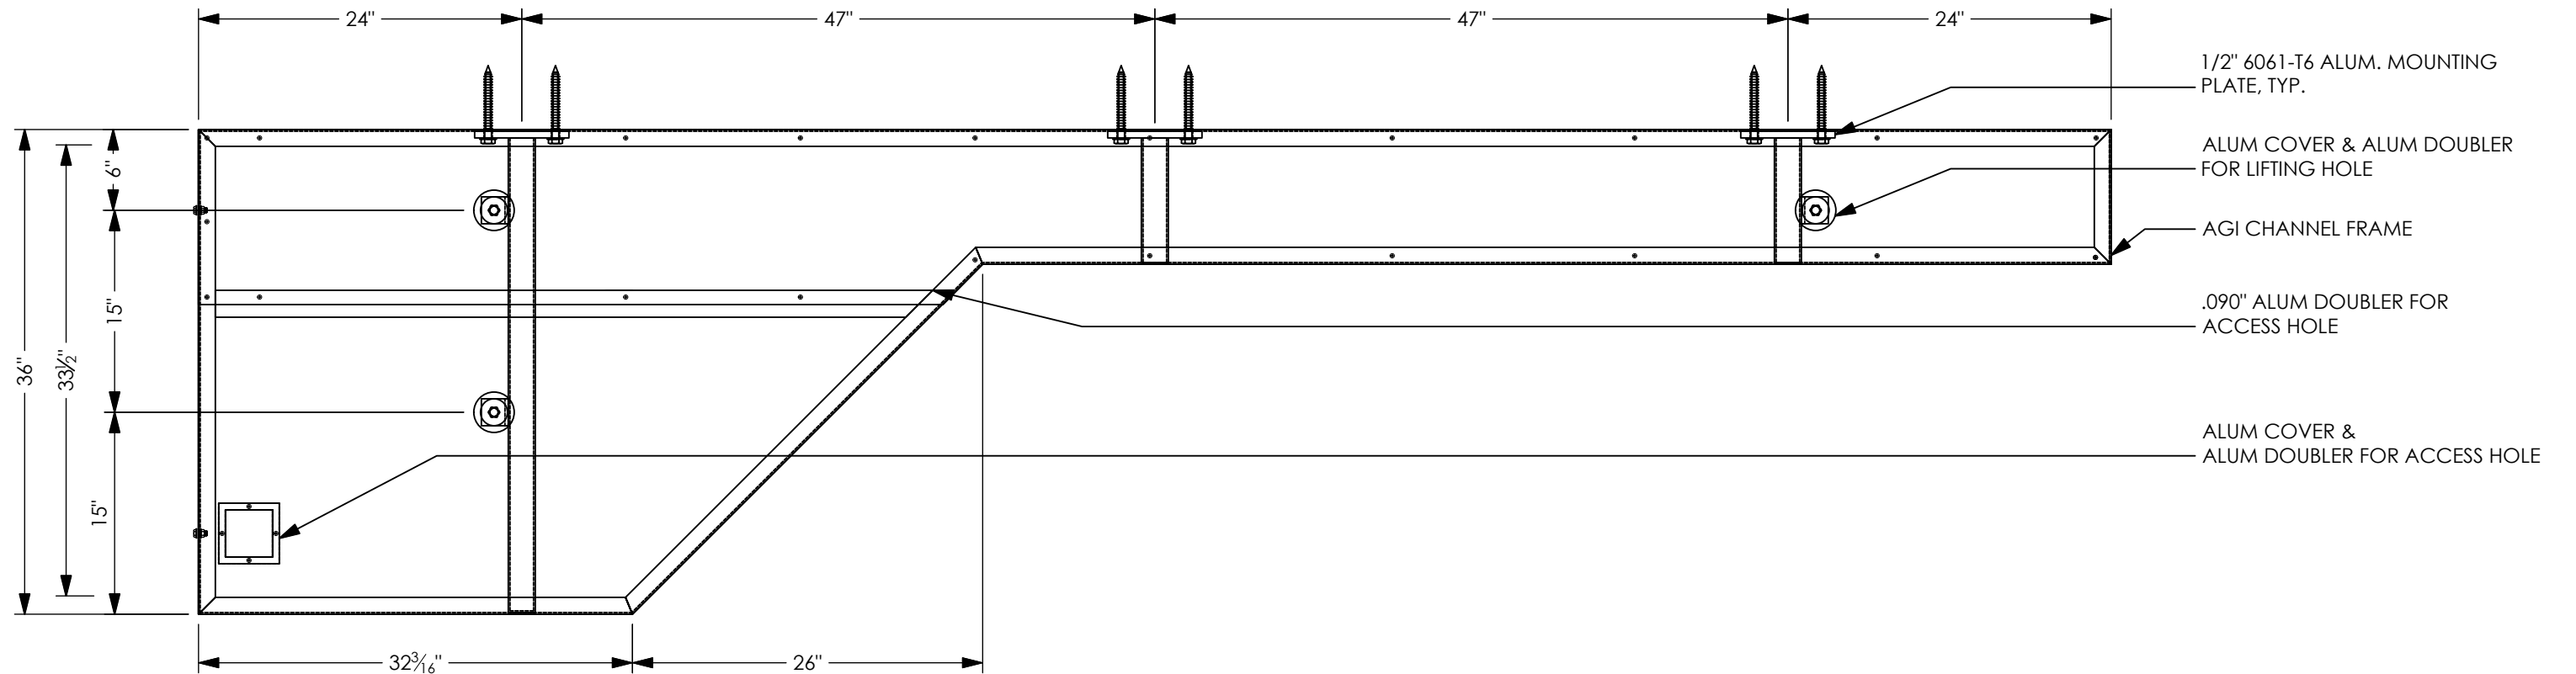

TOP SECTION VIEW

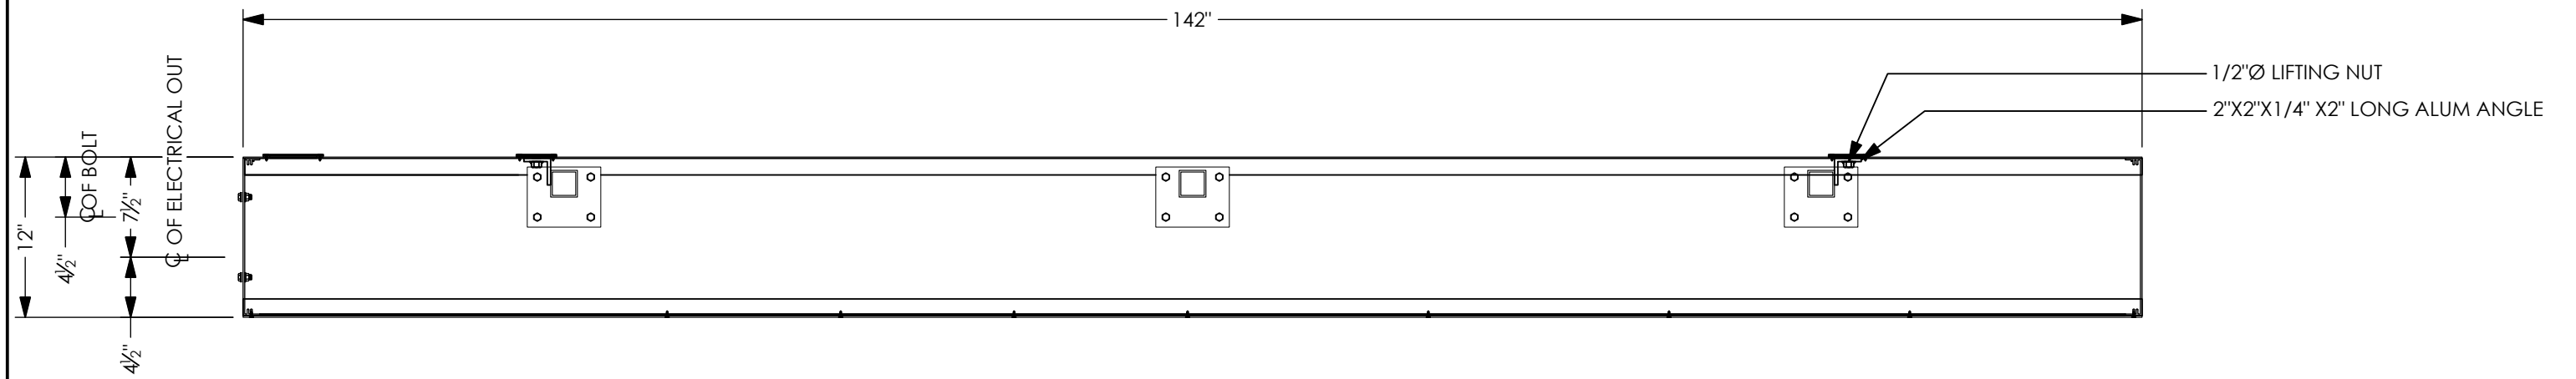

FRONT VIEW SECTIONS 4

Program/Customer:		FORD
Interior/Exterior:	EXTERIOR	
Sign Type:	WALL SIGN	
Engineer:	M. SMITH	
Windspeed:	115MPH/IBC 2012	
Illumination:	ILLUMINATION	
Voltage:	120V	SCALE: 1/4"= 1'-0"



Description:	GRABBER BAR
Part Number:	FOR-C36


4

3


2

1

REVISIONS				
REV	DR NUMBER	REV CHANGE	DATE	DRAFTER
A	54568	INITIAL RELEASE	02.23.22	ELL

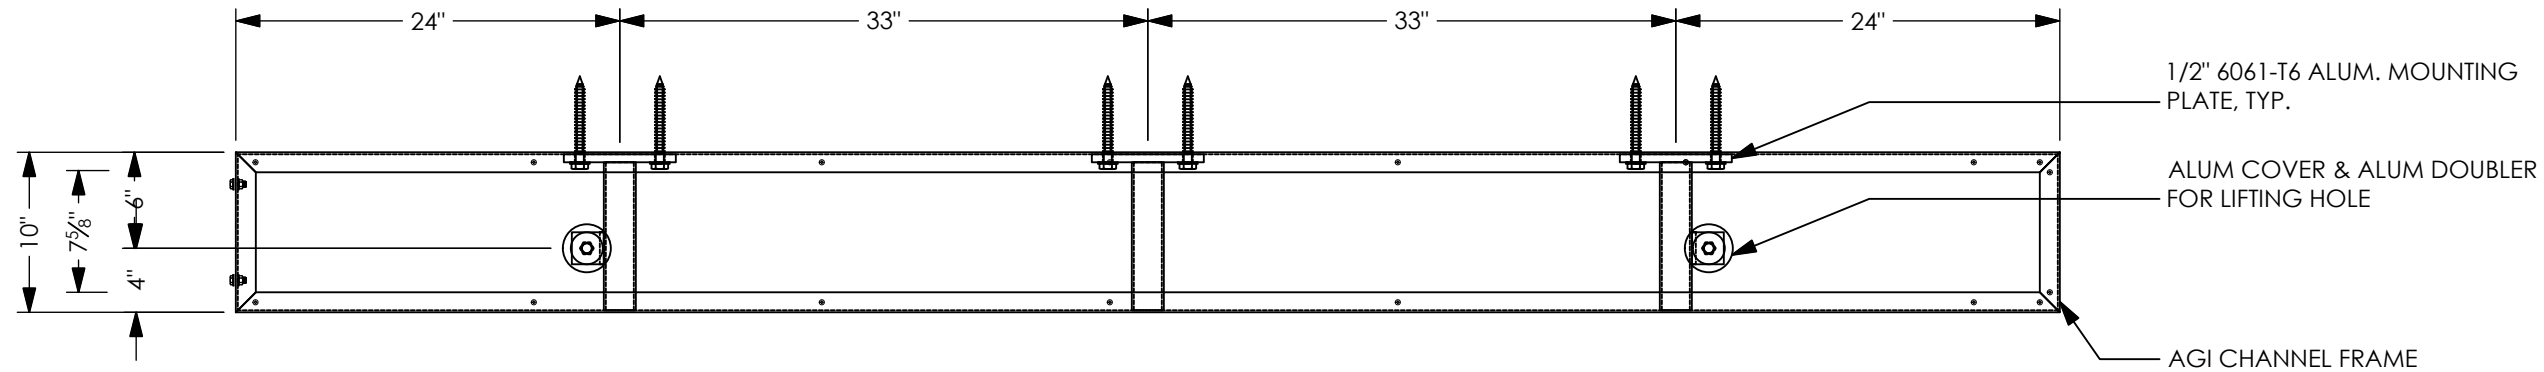

TOP SECTION VIEW

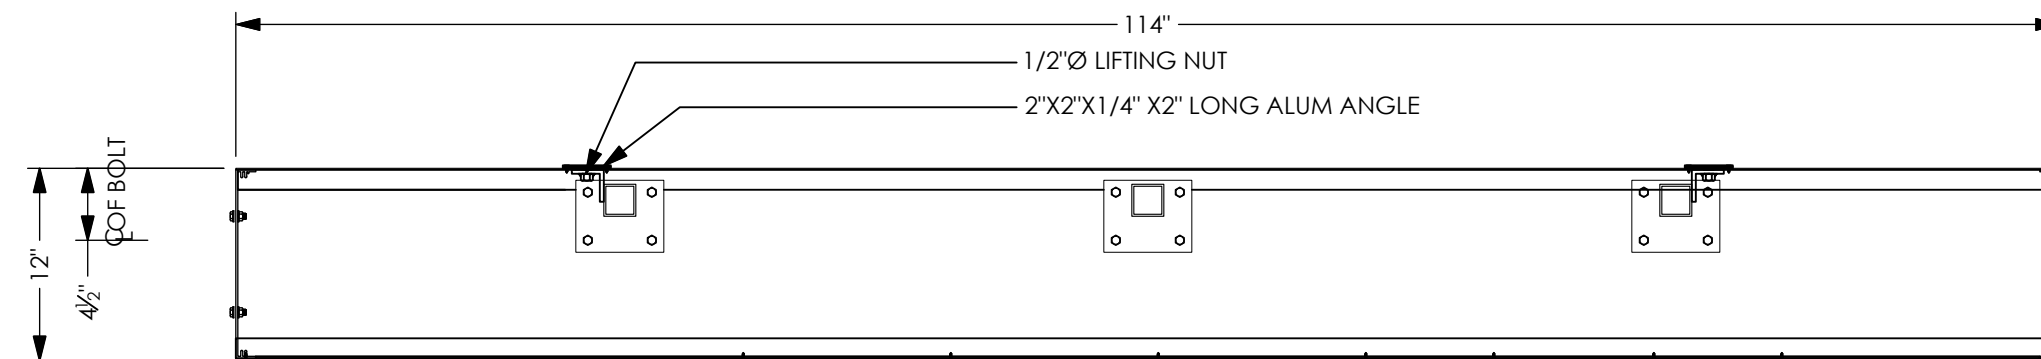

FRONT VIEW SECTION 5

Program/Customer:		FORD
Interior/Exterior:	EXTERIOR	
Sign Type:	WALL SIGN	
Engineer:	M. SMITH	
Windspeed:	115MPH/IBC 2012	
Illumination:	ILLUMINATION	
Voltage:	120V	SCALE: 1/4"= 1'-0"



Description:
GRABBER BAR
Part Number:
FOR-C36


4

3

2

1

REVISIONS				
REV	DR NUMBER	REV CHANGE	DATE	DRAFTER
A	54568	INITIAL RELEASE	02.23.22	ELL

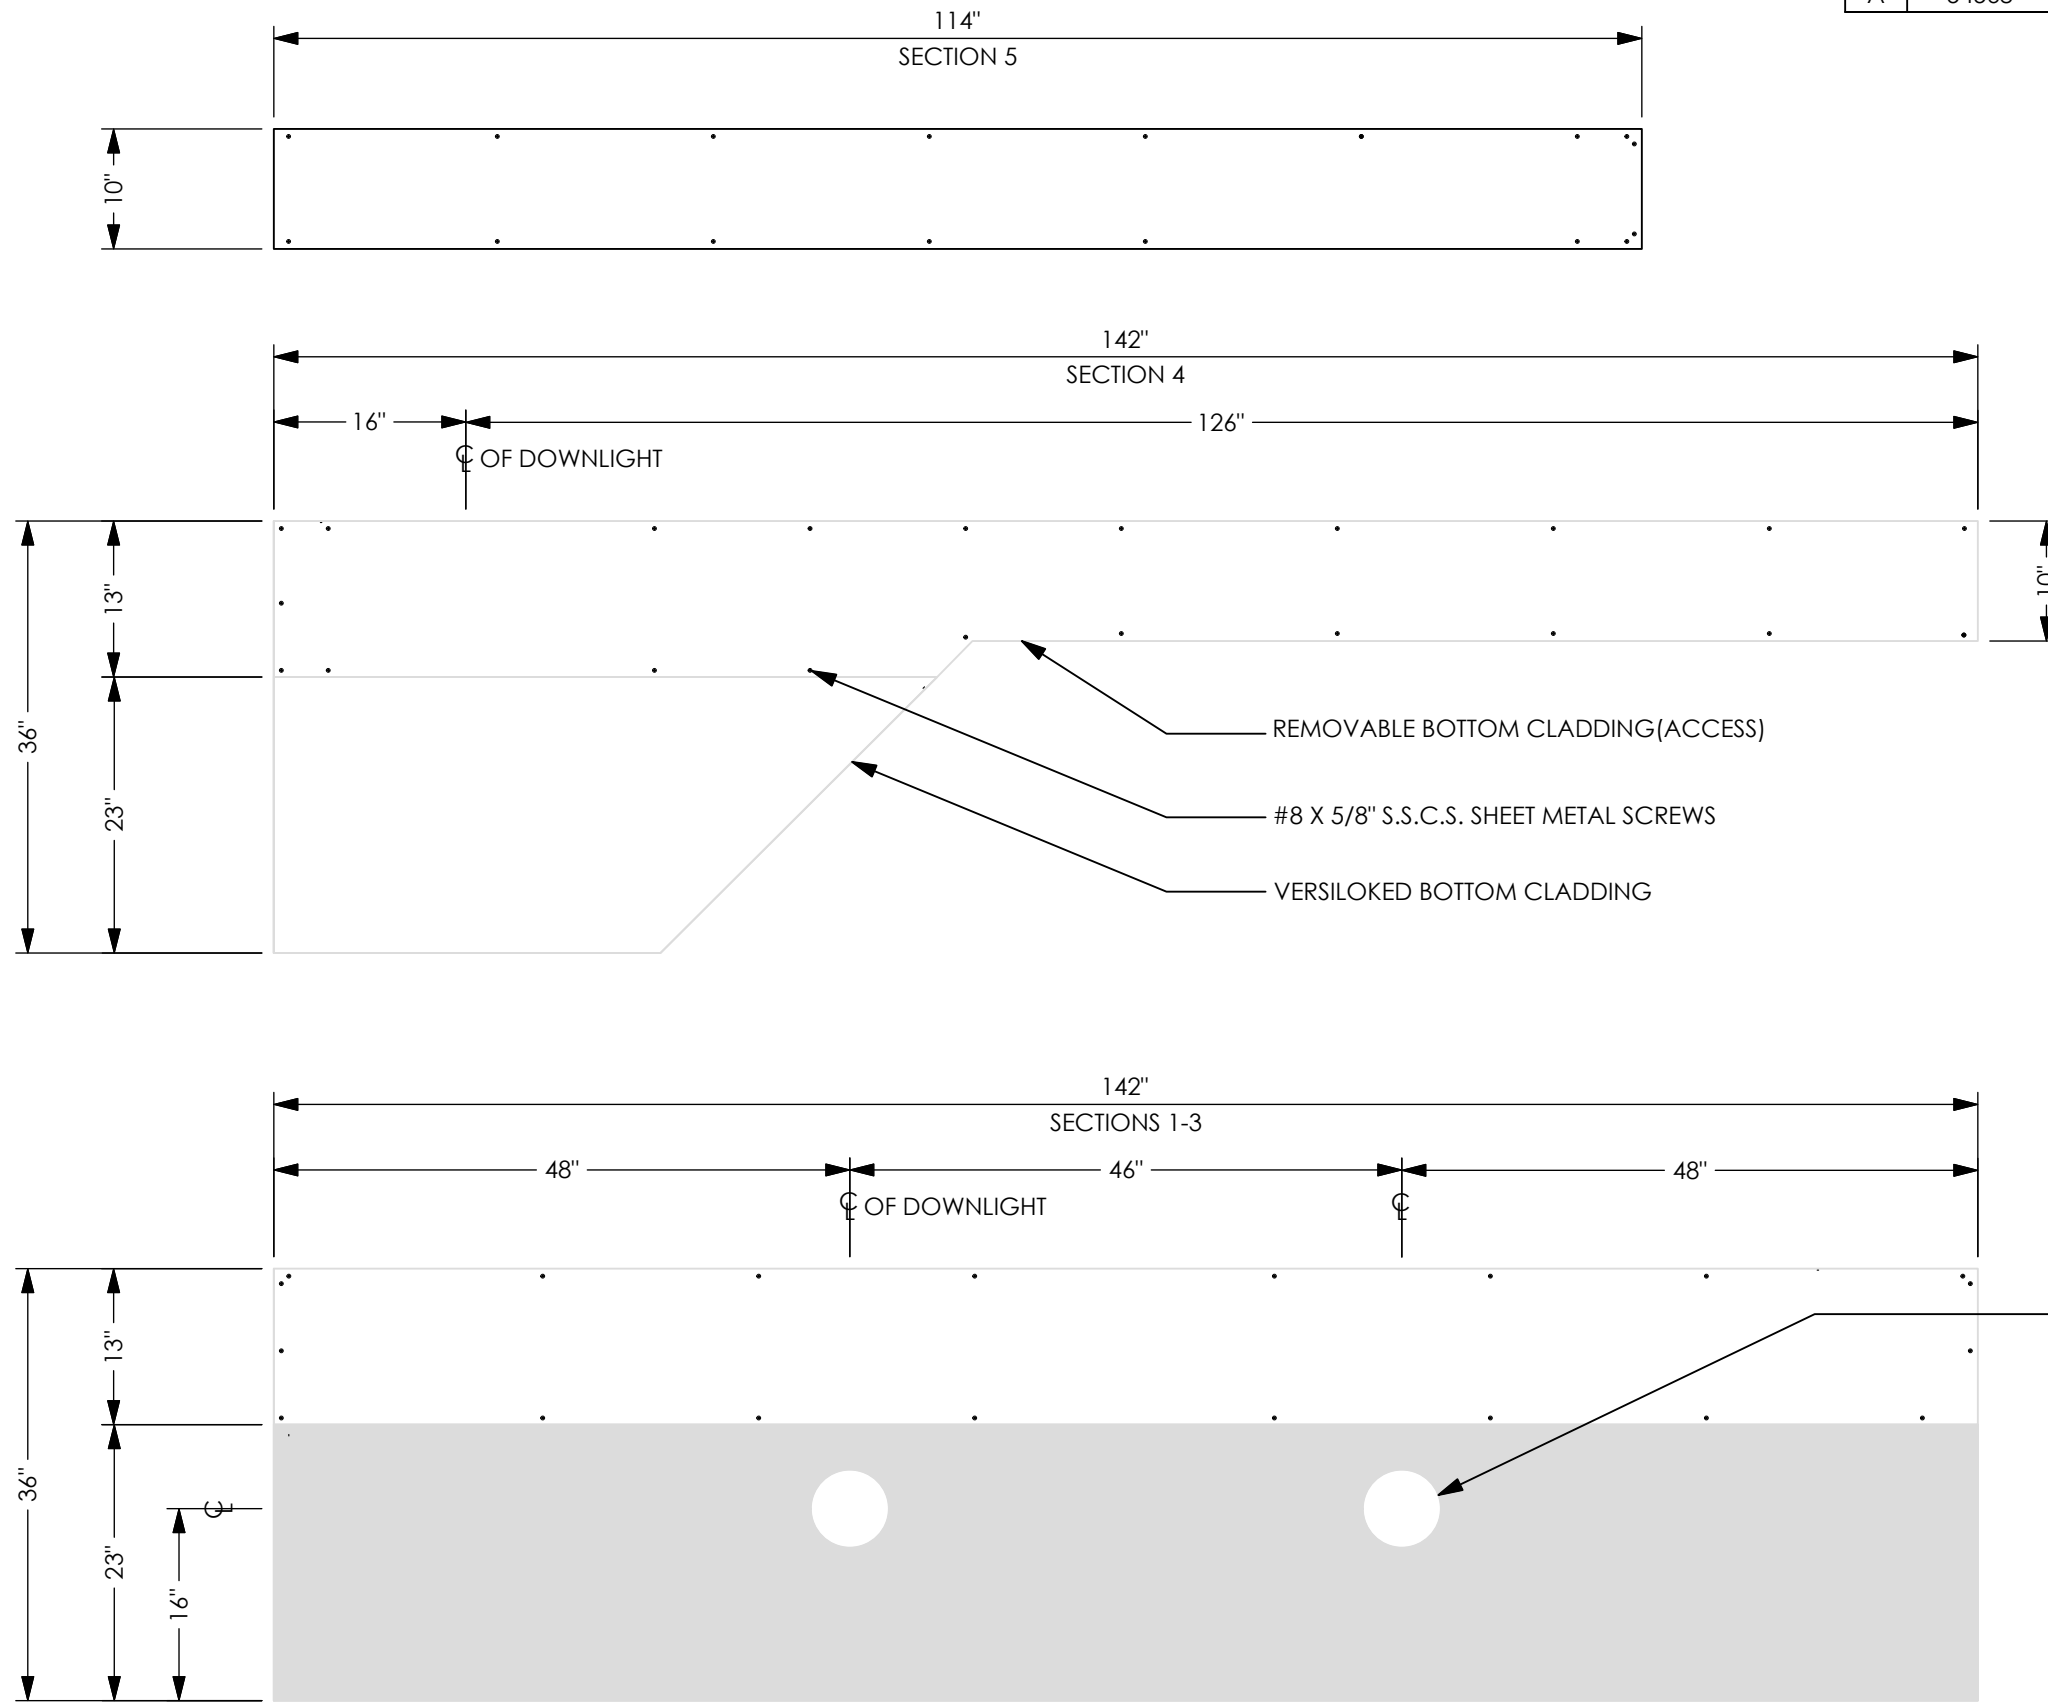

REMOVABLE CLADDING PLAN VIEW
SCALE: 3/4" = 1'-0"

Program/Customer:		FORD	
Interior/Exterior:	EXTERIOR		
Sign Type:	WALL SIGN		
Engineer:	M. SMITH		
Windspeed:	115MPH/IBC 2012		
Illumination:	ILLUMINATION		
Voltage:	120V	SCALE: 1/4" = 1'-0"	




Description:	GRABBER BAR
Part Number:	FOR-C36


ANSI B-SIZE DRAWING-AUTOCAD 09.30.21

NOTE:
 1. VERIFY MOUNTING CONDITION.
 2. SEAL ALL WALL PENETRATIONS TO PREVENT WATER INTRUSION.

REVISIONS				
REV	DR NUMBER	REV CHANGE	DATE	DRAFTER
A	54568	INITIAL RELEASE	02.23.22	ELL

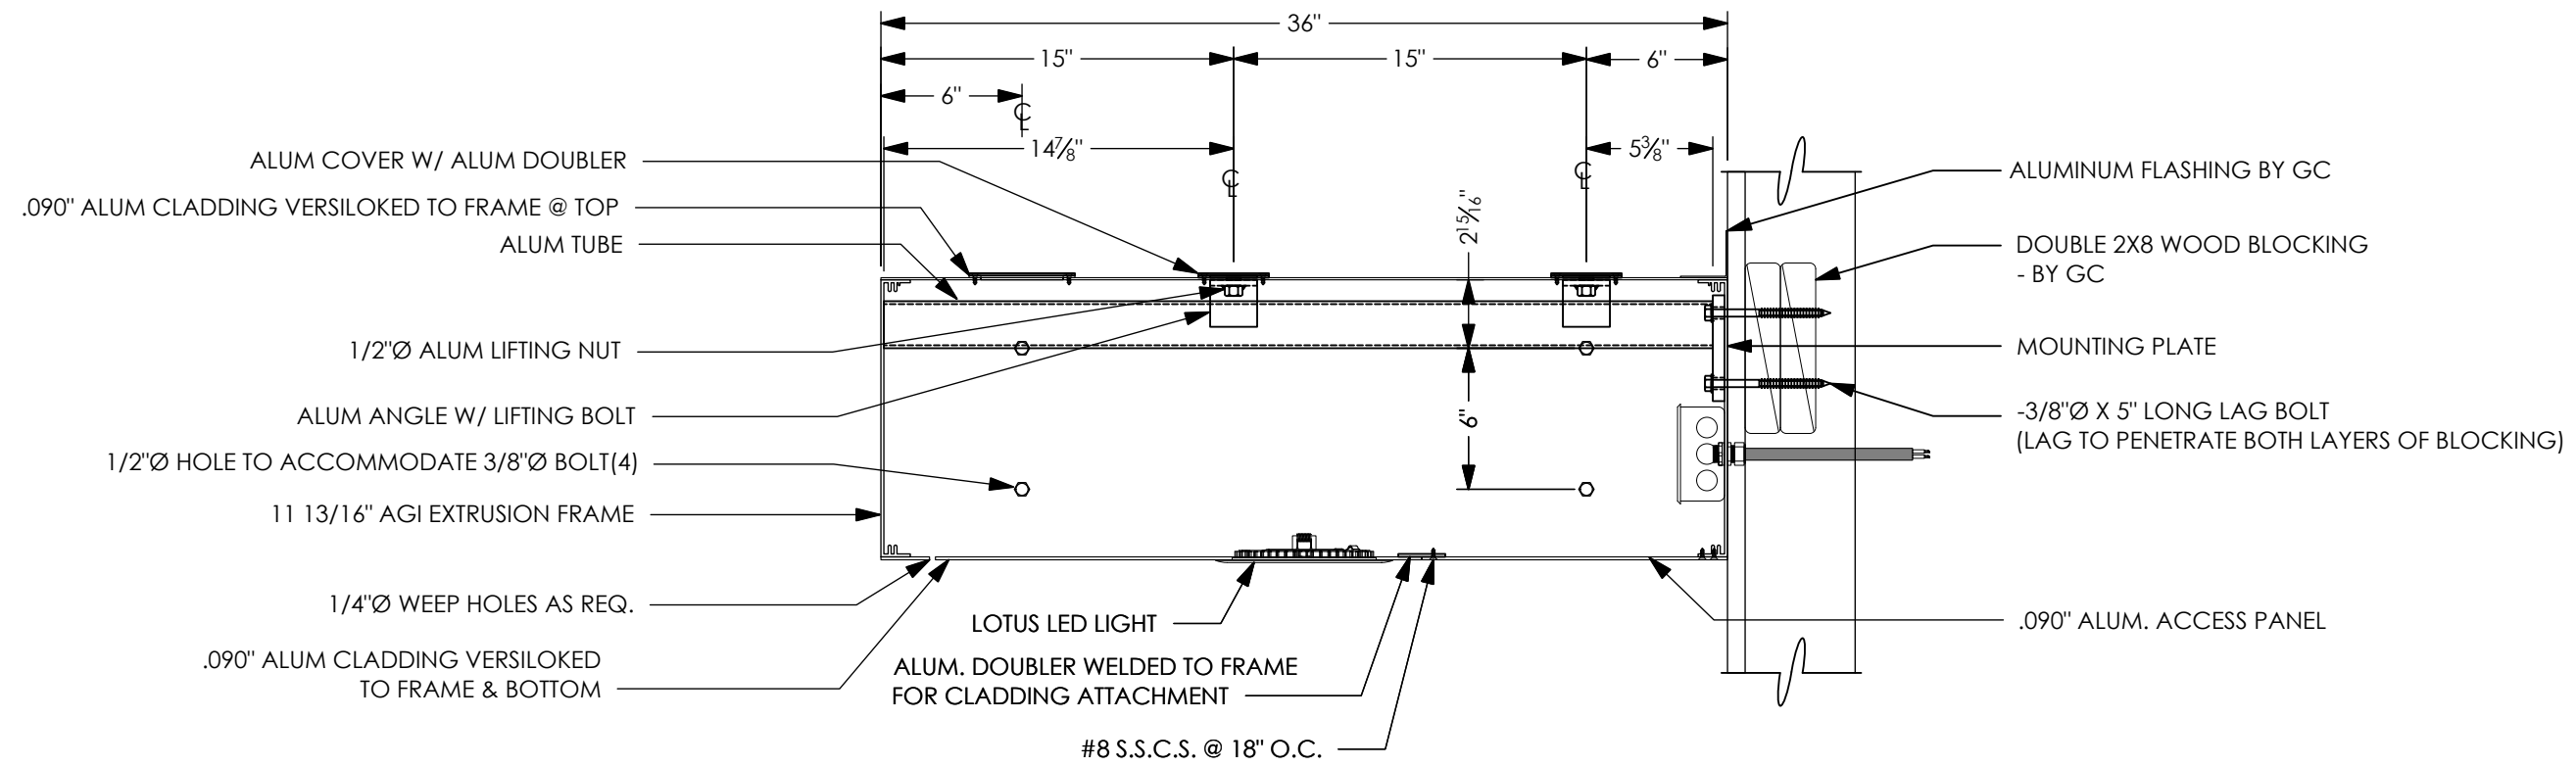

SIDE SECTION VIEW WOOD BLOCKING MOUNTING
 SCALE: 1/8" = 1"

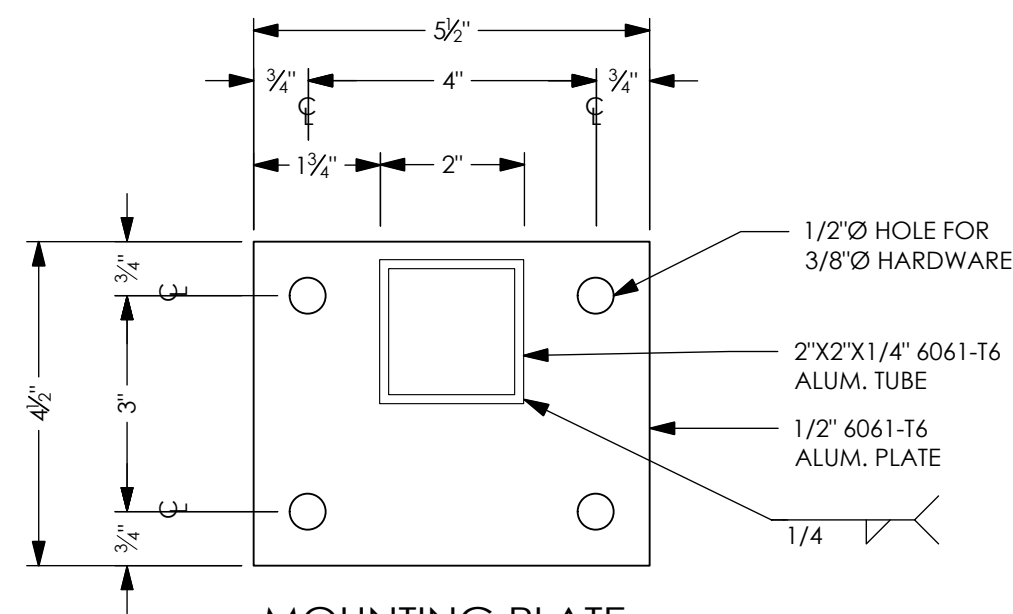

MOUNTING PLATE
 SCALE: 3/8" = 1"


Program/Customer:		FORD	
Interior/Exterior:	EXTERIOR		
Sign Type:	WALL SIGN		
Engineer:	M. SMITH		
Windspeed:	115MPH/IBC 2012		
Illumination:	ILLUMINATION		
Voltage:	120V	SCALE: 1/4" = 1'-0"	




Description:
 GRABBER BAR
 Part Number:

NOTE:
1. VERIFY MOUNTING CONDITION.

REVISIONS				
REV	DR NUMBER	REV CHANGE	DATE	DRAFTER
A	54568	INITIAL RELEASE	02.23.22	ELL

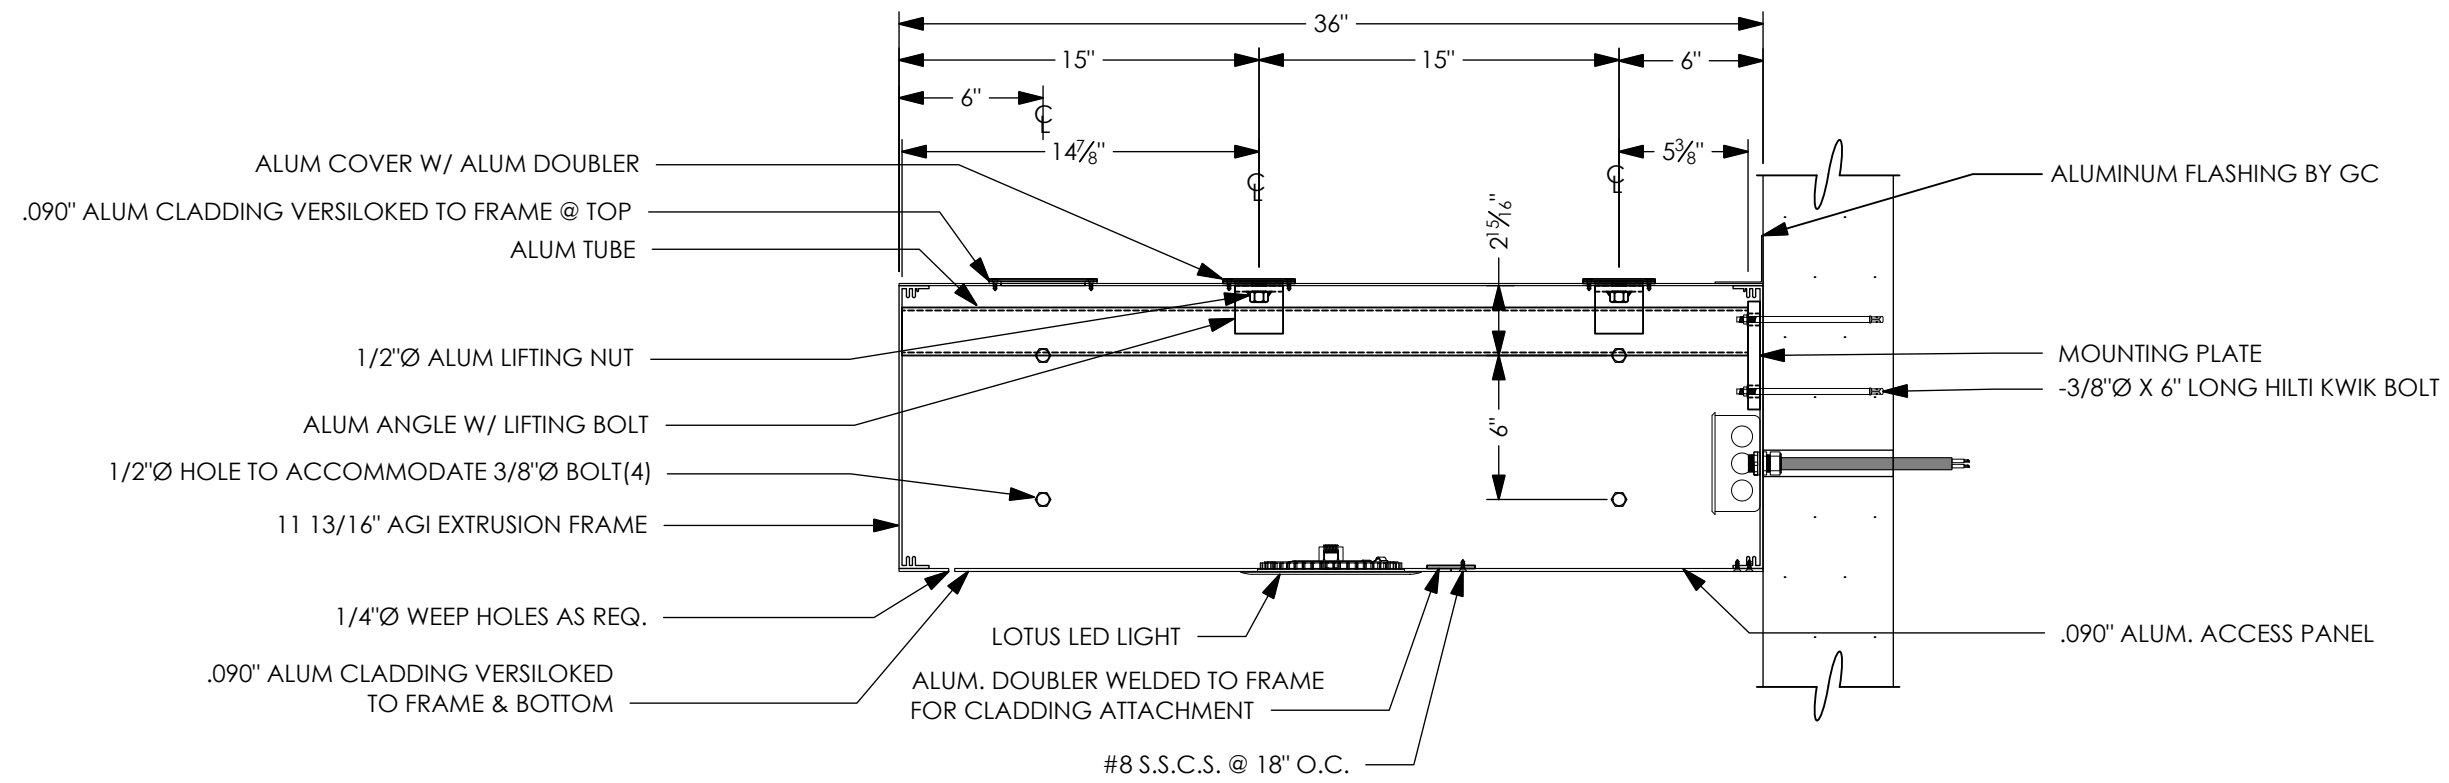

SIDE SECTION VIEW CONCRETE MOUNTING
SCALE: 1/8" = 1"

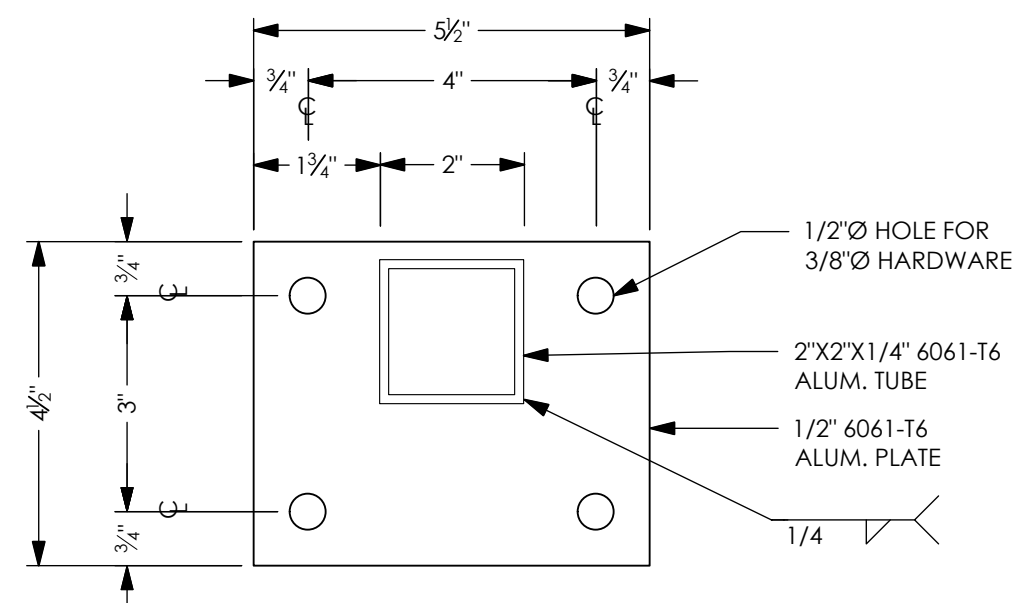

MOUNTING PLATE
SCALE: 3/8" = 1"

Program/Customer:		FORD	
Interior/Exterior:	EXTERIOR		
Sign Type:	WALL SIGN		
Engineer:	M. SMITH		
Windspeed:	115MPH/IBC 2012		
Illumination:	ILLUMINATION		
Voltage:	120V	SCALE: 1/4" = 1'-0"	




















Description:
GRABBER BAR
Part Number:

SHEET NOTES

CUSTOMIZATION OF SMART BOX TO BE CONFIRMED.

SAFE KEYMASTER

 <p>KEY MASTER</p> <p>100-10,000 Keys</p> <p>Sales, Spare Keys, and Dealer Plates</p>	 <p>KEY MASTER SOLO</p> <p>8-16 Keys</p> <p>Self-Service Drop off or Pick Up</p>	 <p>KEY MASTER LITE</p> <p>24-96 Keys</p> <p>Service, Detail, Rental Cars, etc.</p>			
 <p>The only cloud based system on the market</p>	 <p>Over 100+ vendor integrations</p>	 <p>Automatic key and vehicle labels</p>			
 <p>4K Image of every transaction</p>	 <p>7 KeyTag color options</p>	 <p>Dealer Plate Control</p>			
					
 <p>Book in Vehicles</p>	 <p>Add Notes</p>	 <p>KeyTransfer</p>	 <p>Find Cars</p>	 <p>Find the Key Status</p>	 <p>Remove Keys With Your Phone</p>

1MICRO™  | 1Micro.com | 952-448-7000 | Sales@1Micro.com



Prototypical Details

Scale

These drawings are for communication of design intent only. These drawings are not suited or intended for construction or fabrication.

KEY MANAGEMENT

E 300

SHEET NOTES

CUSTOMIZATION OF SMART BOX TO BE CONFIRMED.



Prototypical Details




Dealership Key Management System

Ultimate in guest convenience and ensure only authorized access to all vehicles on premises


- Visibility & Accountability
- Rapid Sales Access
- Customer After Hours
- Real-time Monitoring

A Great Tool For Vehicle Inventory

"Keycafe has been a simple, secure system for storing our vehicle inventory keys and keeping everyone accountable. It's greatly increased our staff's productivity by cutting down the time it takes to track down a "missing" key. Since Keycafe records a key's history of pick-ups and drop-offs, we can easily find any vehicle regardless if it's with a client, in the service garage, or parked on the sales lot."

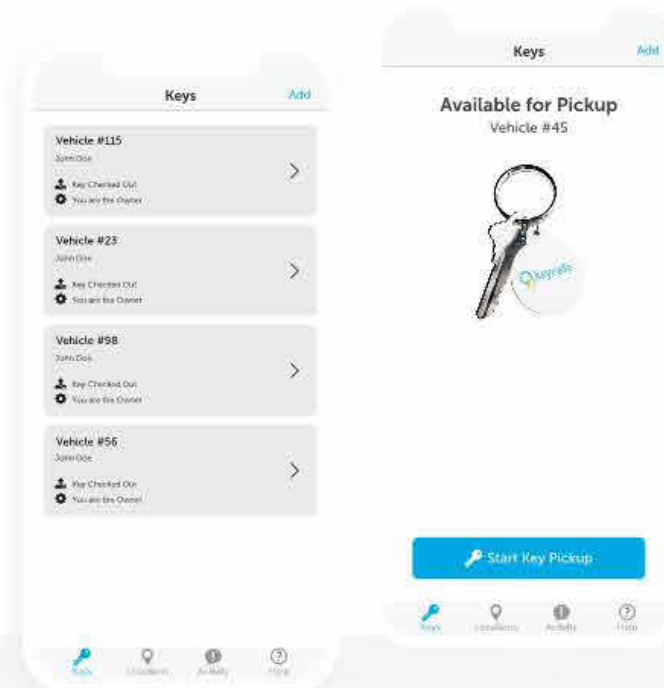Cloud management platform

- Instant cloud-based management
 - Single account to manage all keys
 - Control exactly who has access at any time
 - Track down keys quickly
- 

Scan QR code to learn more and book live demo
Or email sales@keycafe.com

Scale

These drawings are for communication of design intent only. These drawings are not suited or intended for construction or fabrication.

KEY MANAGEMENT

E 301



Key Management Simplified | www.keycafe.com